


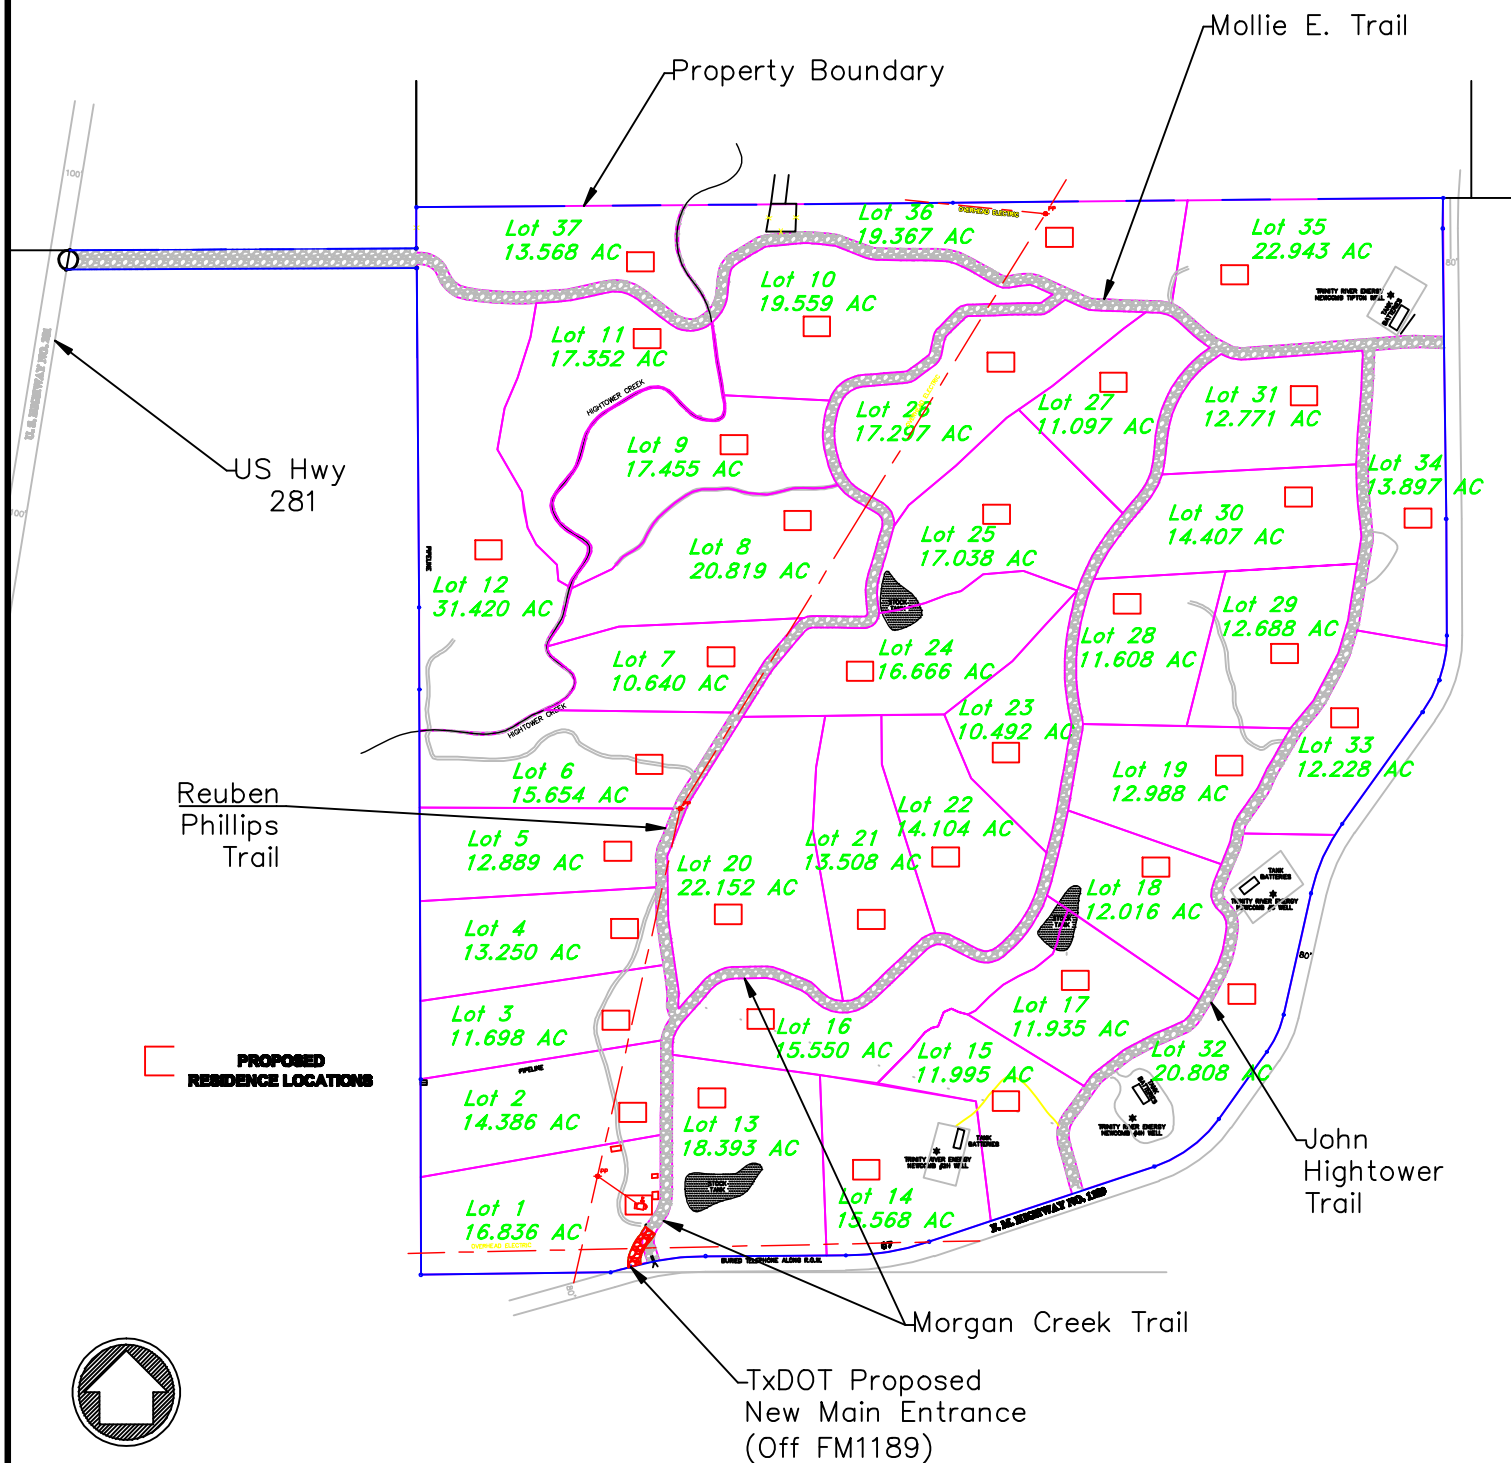

Date
September 7, 2016

Drawn By
Dayne Colahan

Scale
1" = 1000'



Consulting Environmental Engineers, Inc.
230 N. Loop West, Suite 400 • Houston, TX 77028
(281) 441-1111 • Fax: (281) 441-1112 • www.cee-engineers.com

Morgan Creek Estates
3351 FM 1189
Bluff Dale, TX 76433
Site Plan

Exhibit I