




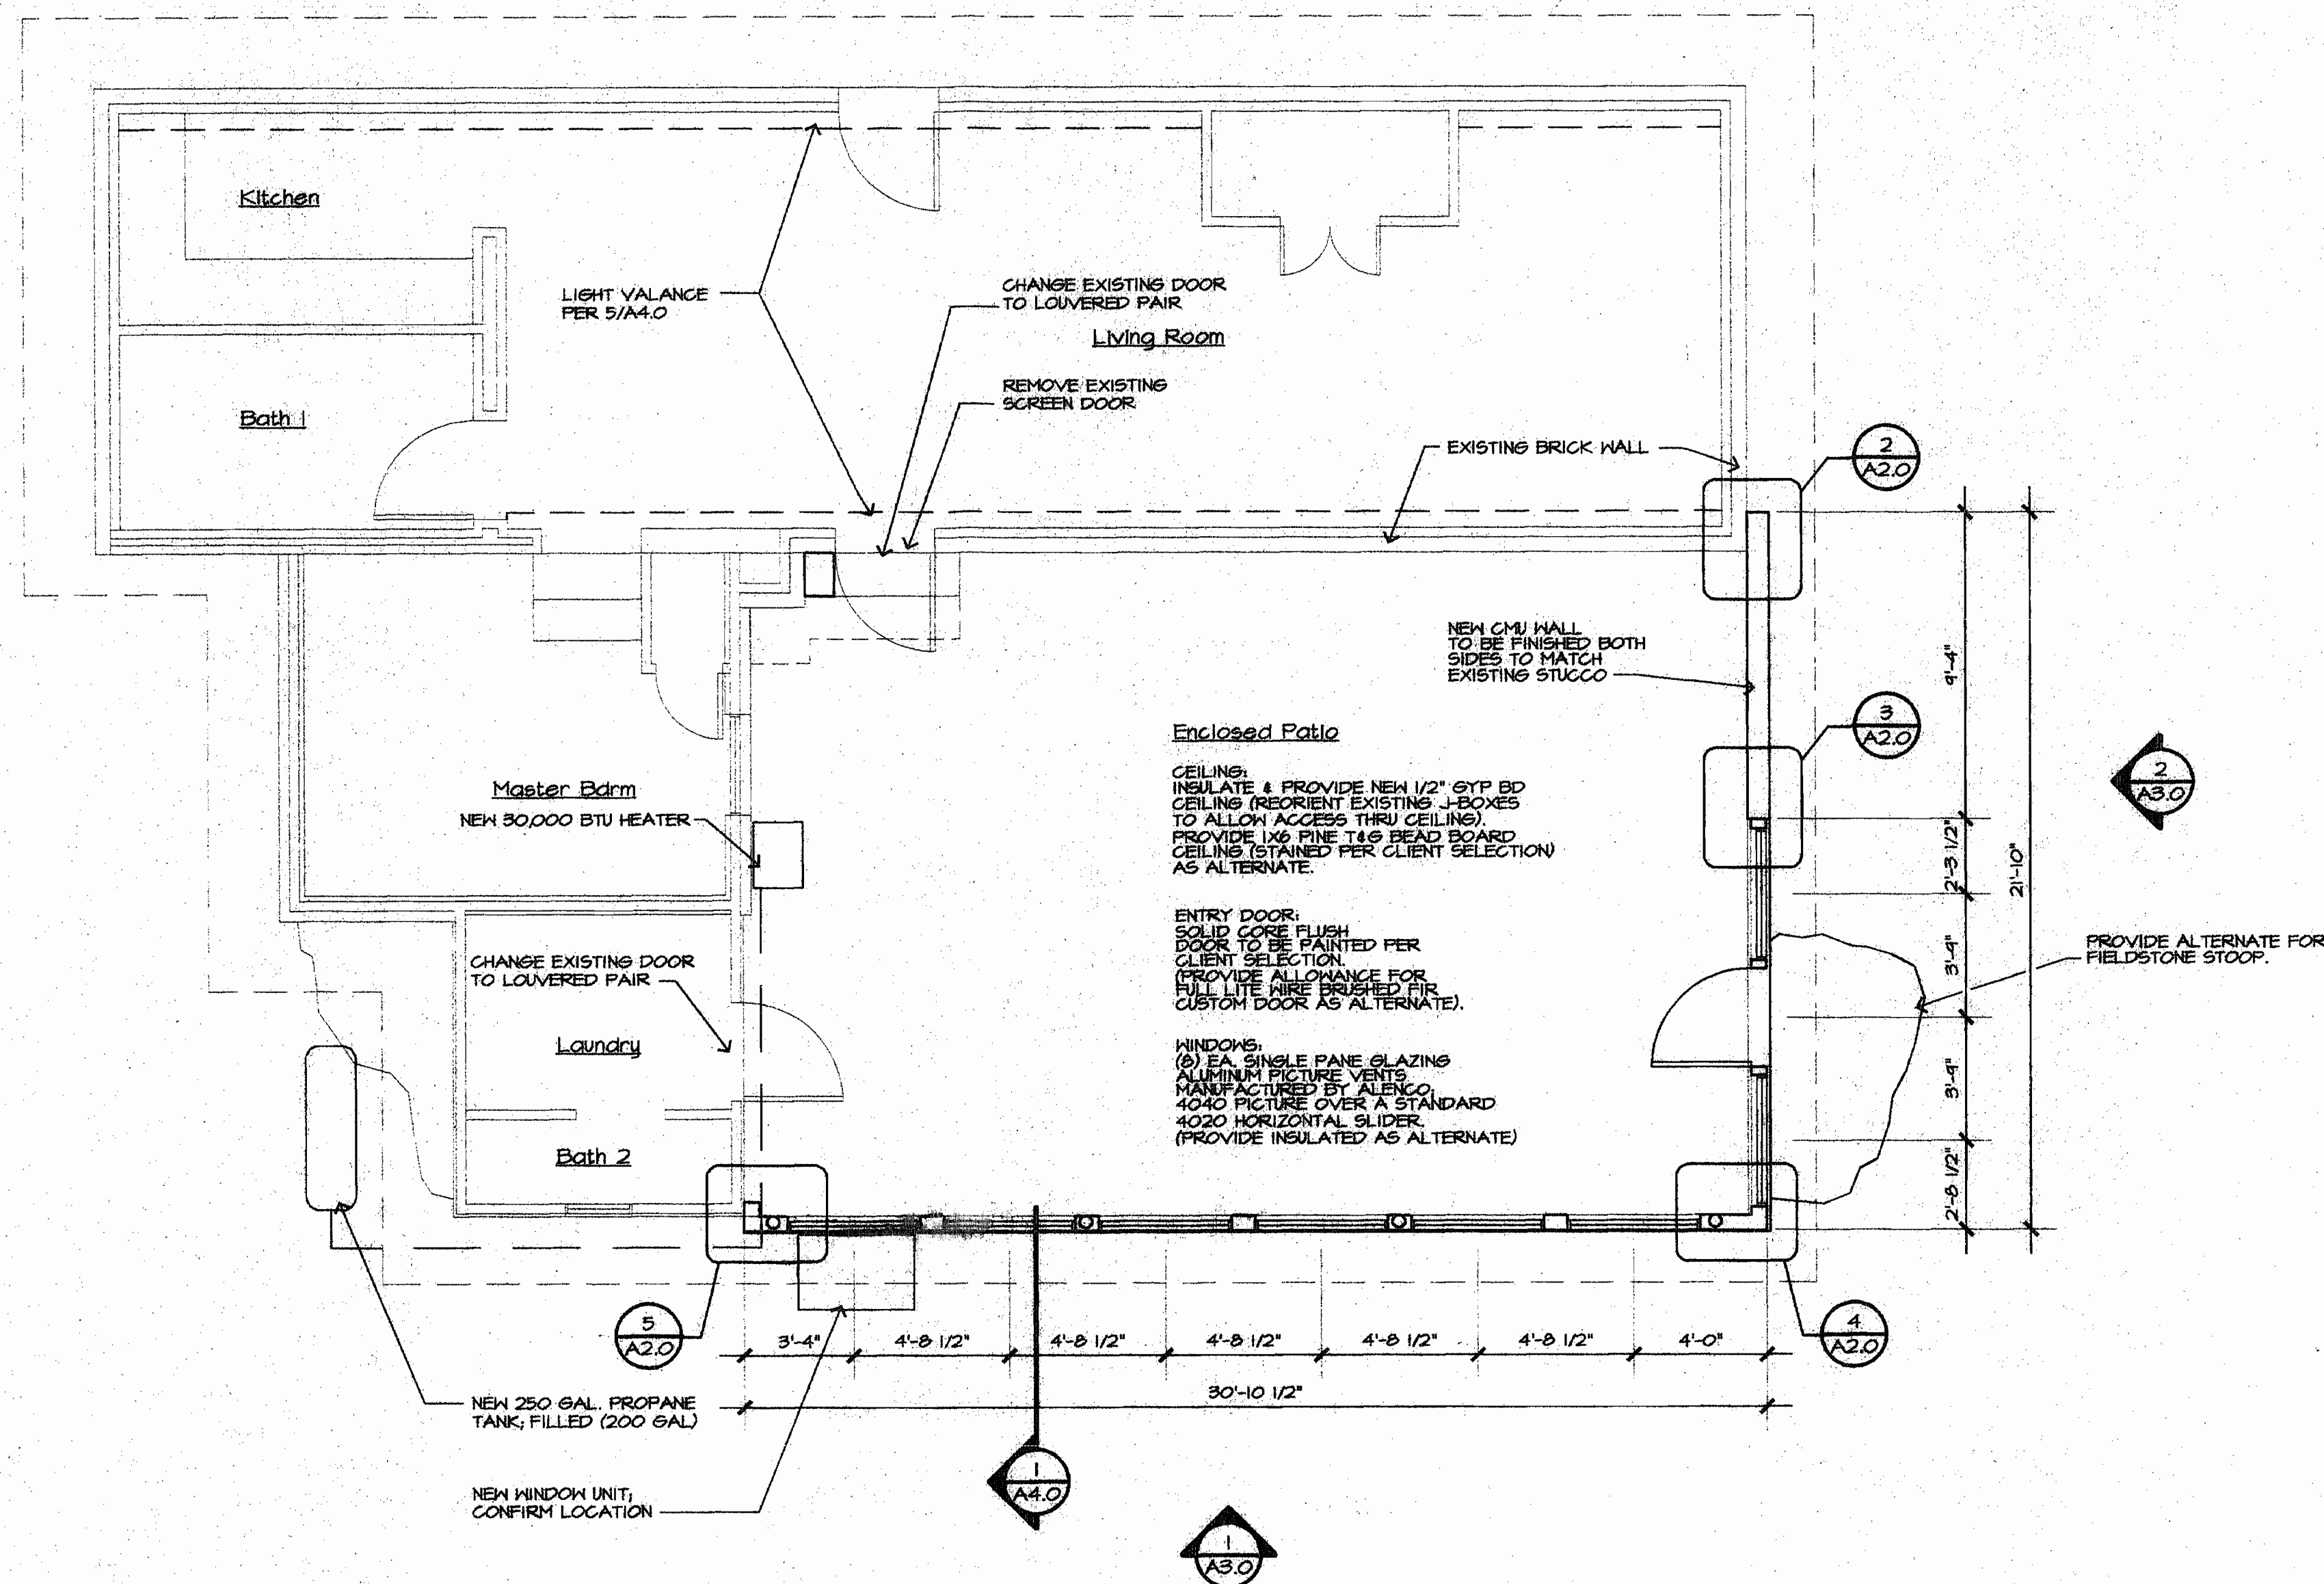


1 FLOOR PLAN
SCALE: 1/4"

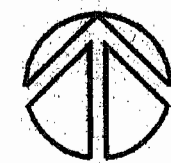


2 CMU TO EXISTING WALL
SCALE: 1 1/2"

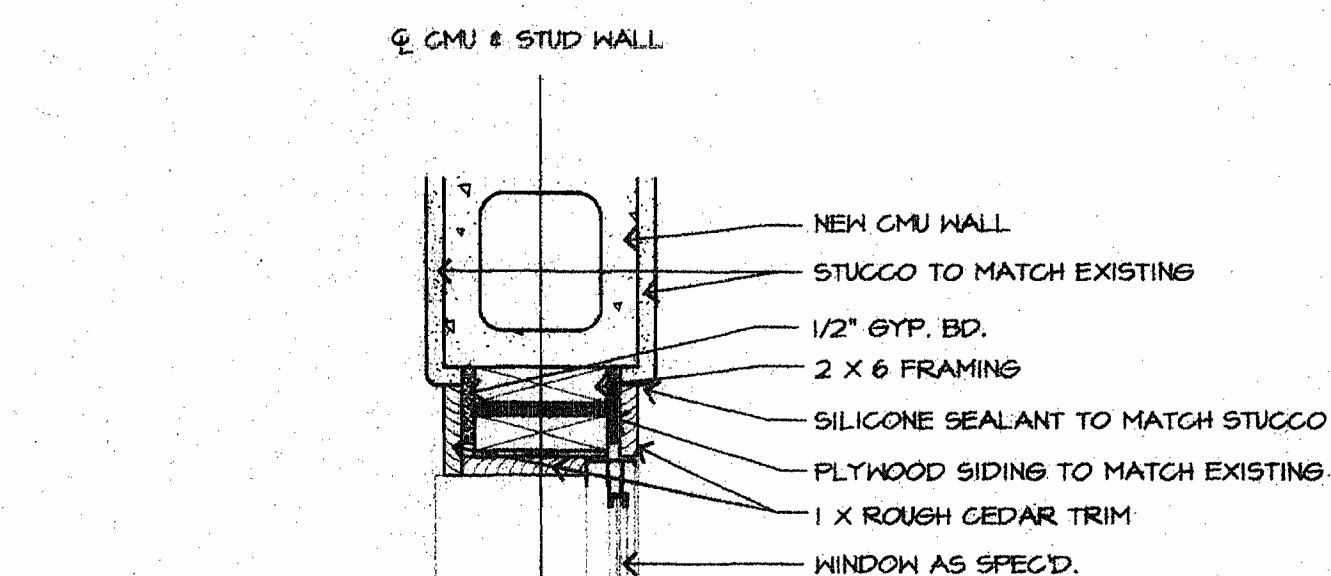



3 CMU TO NEW STUD WALL / JAMB
SCALE: 1 1/2"

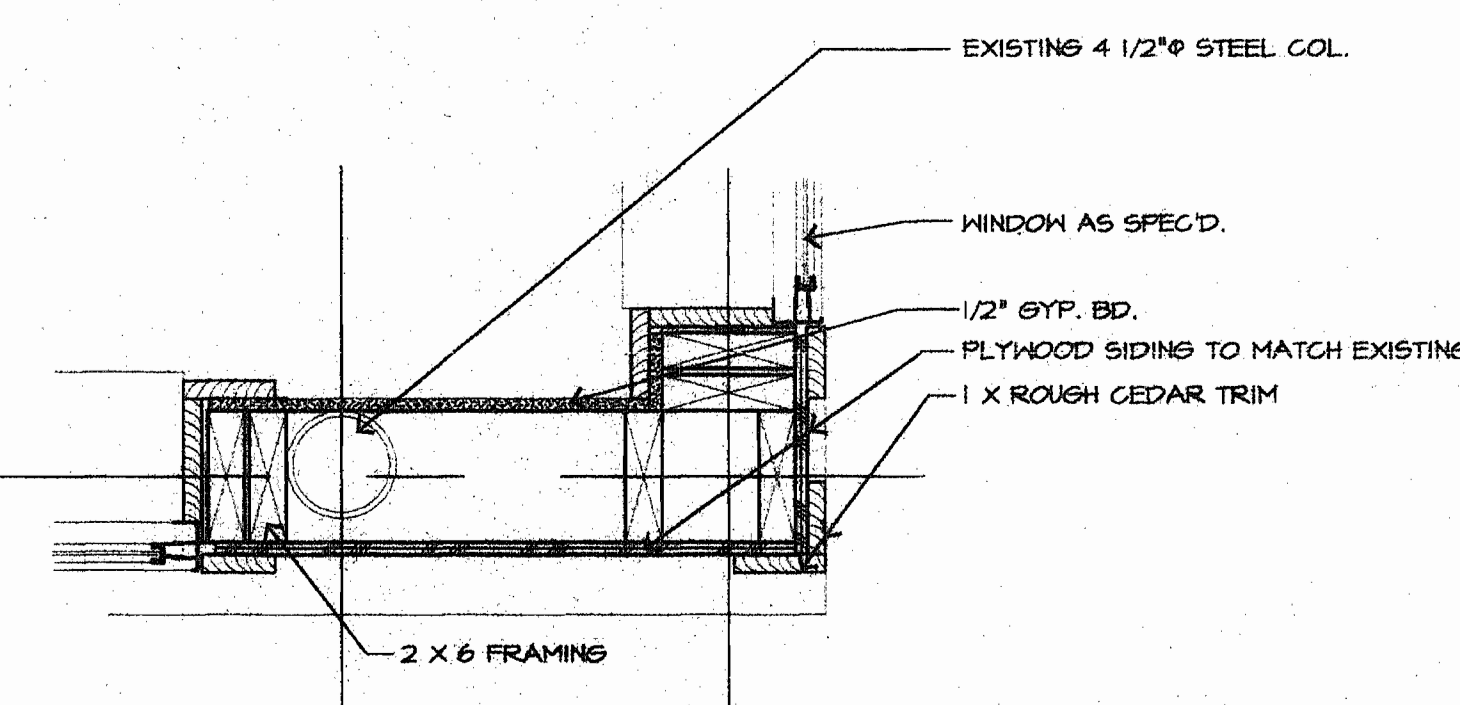

4 NEW TO EXIST. STUD WALL
SCALE: 1 1/2"

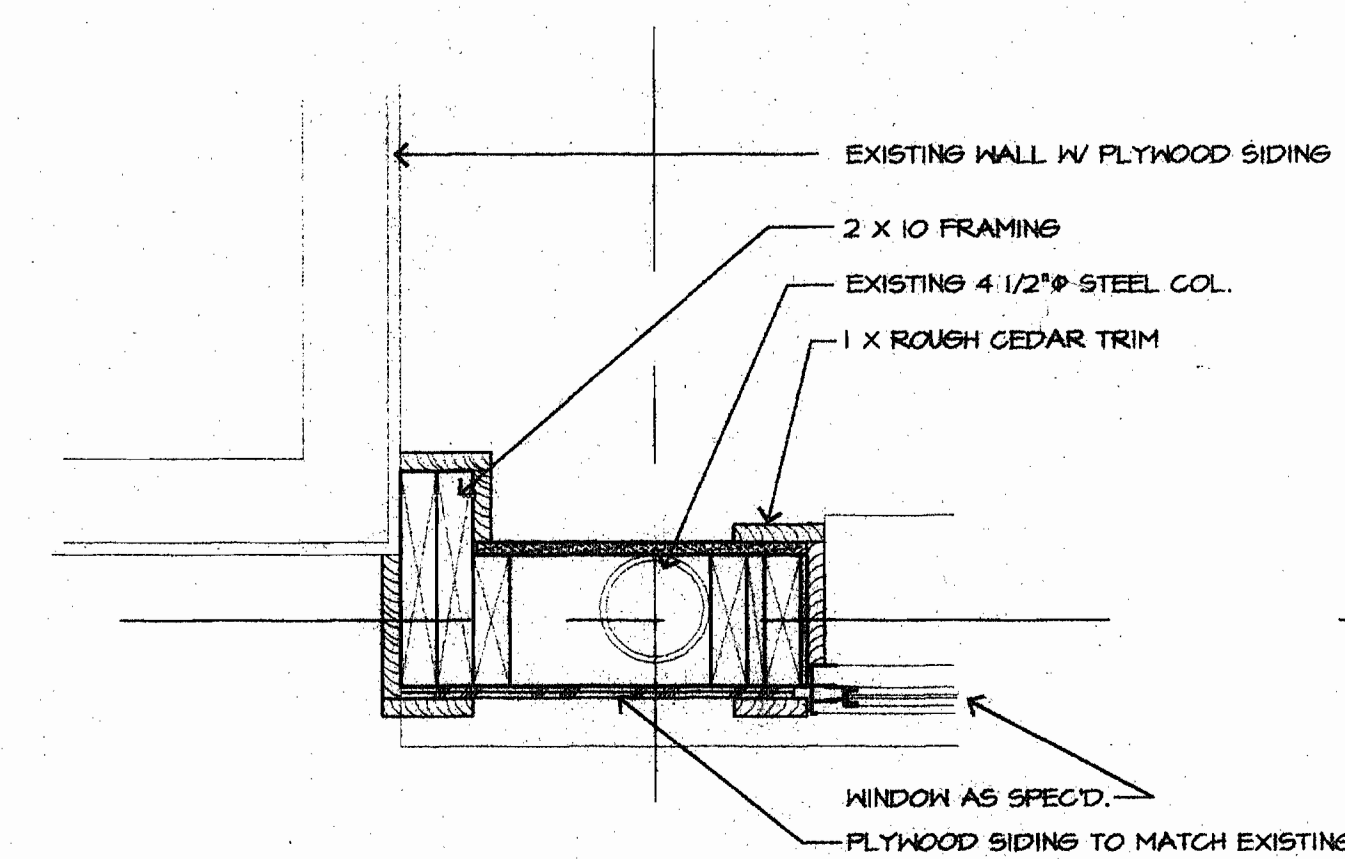


5 CORNER DETAIL
SCALE: 1 1/2"

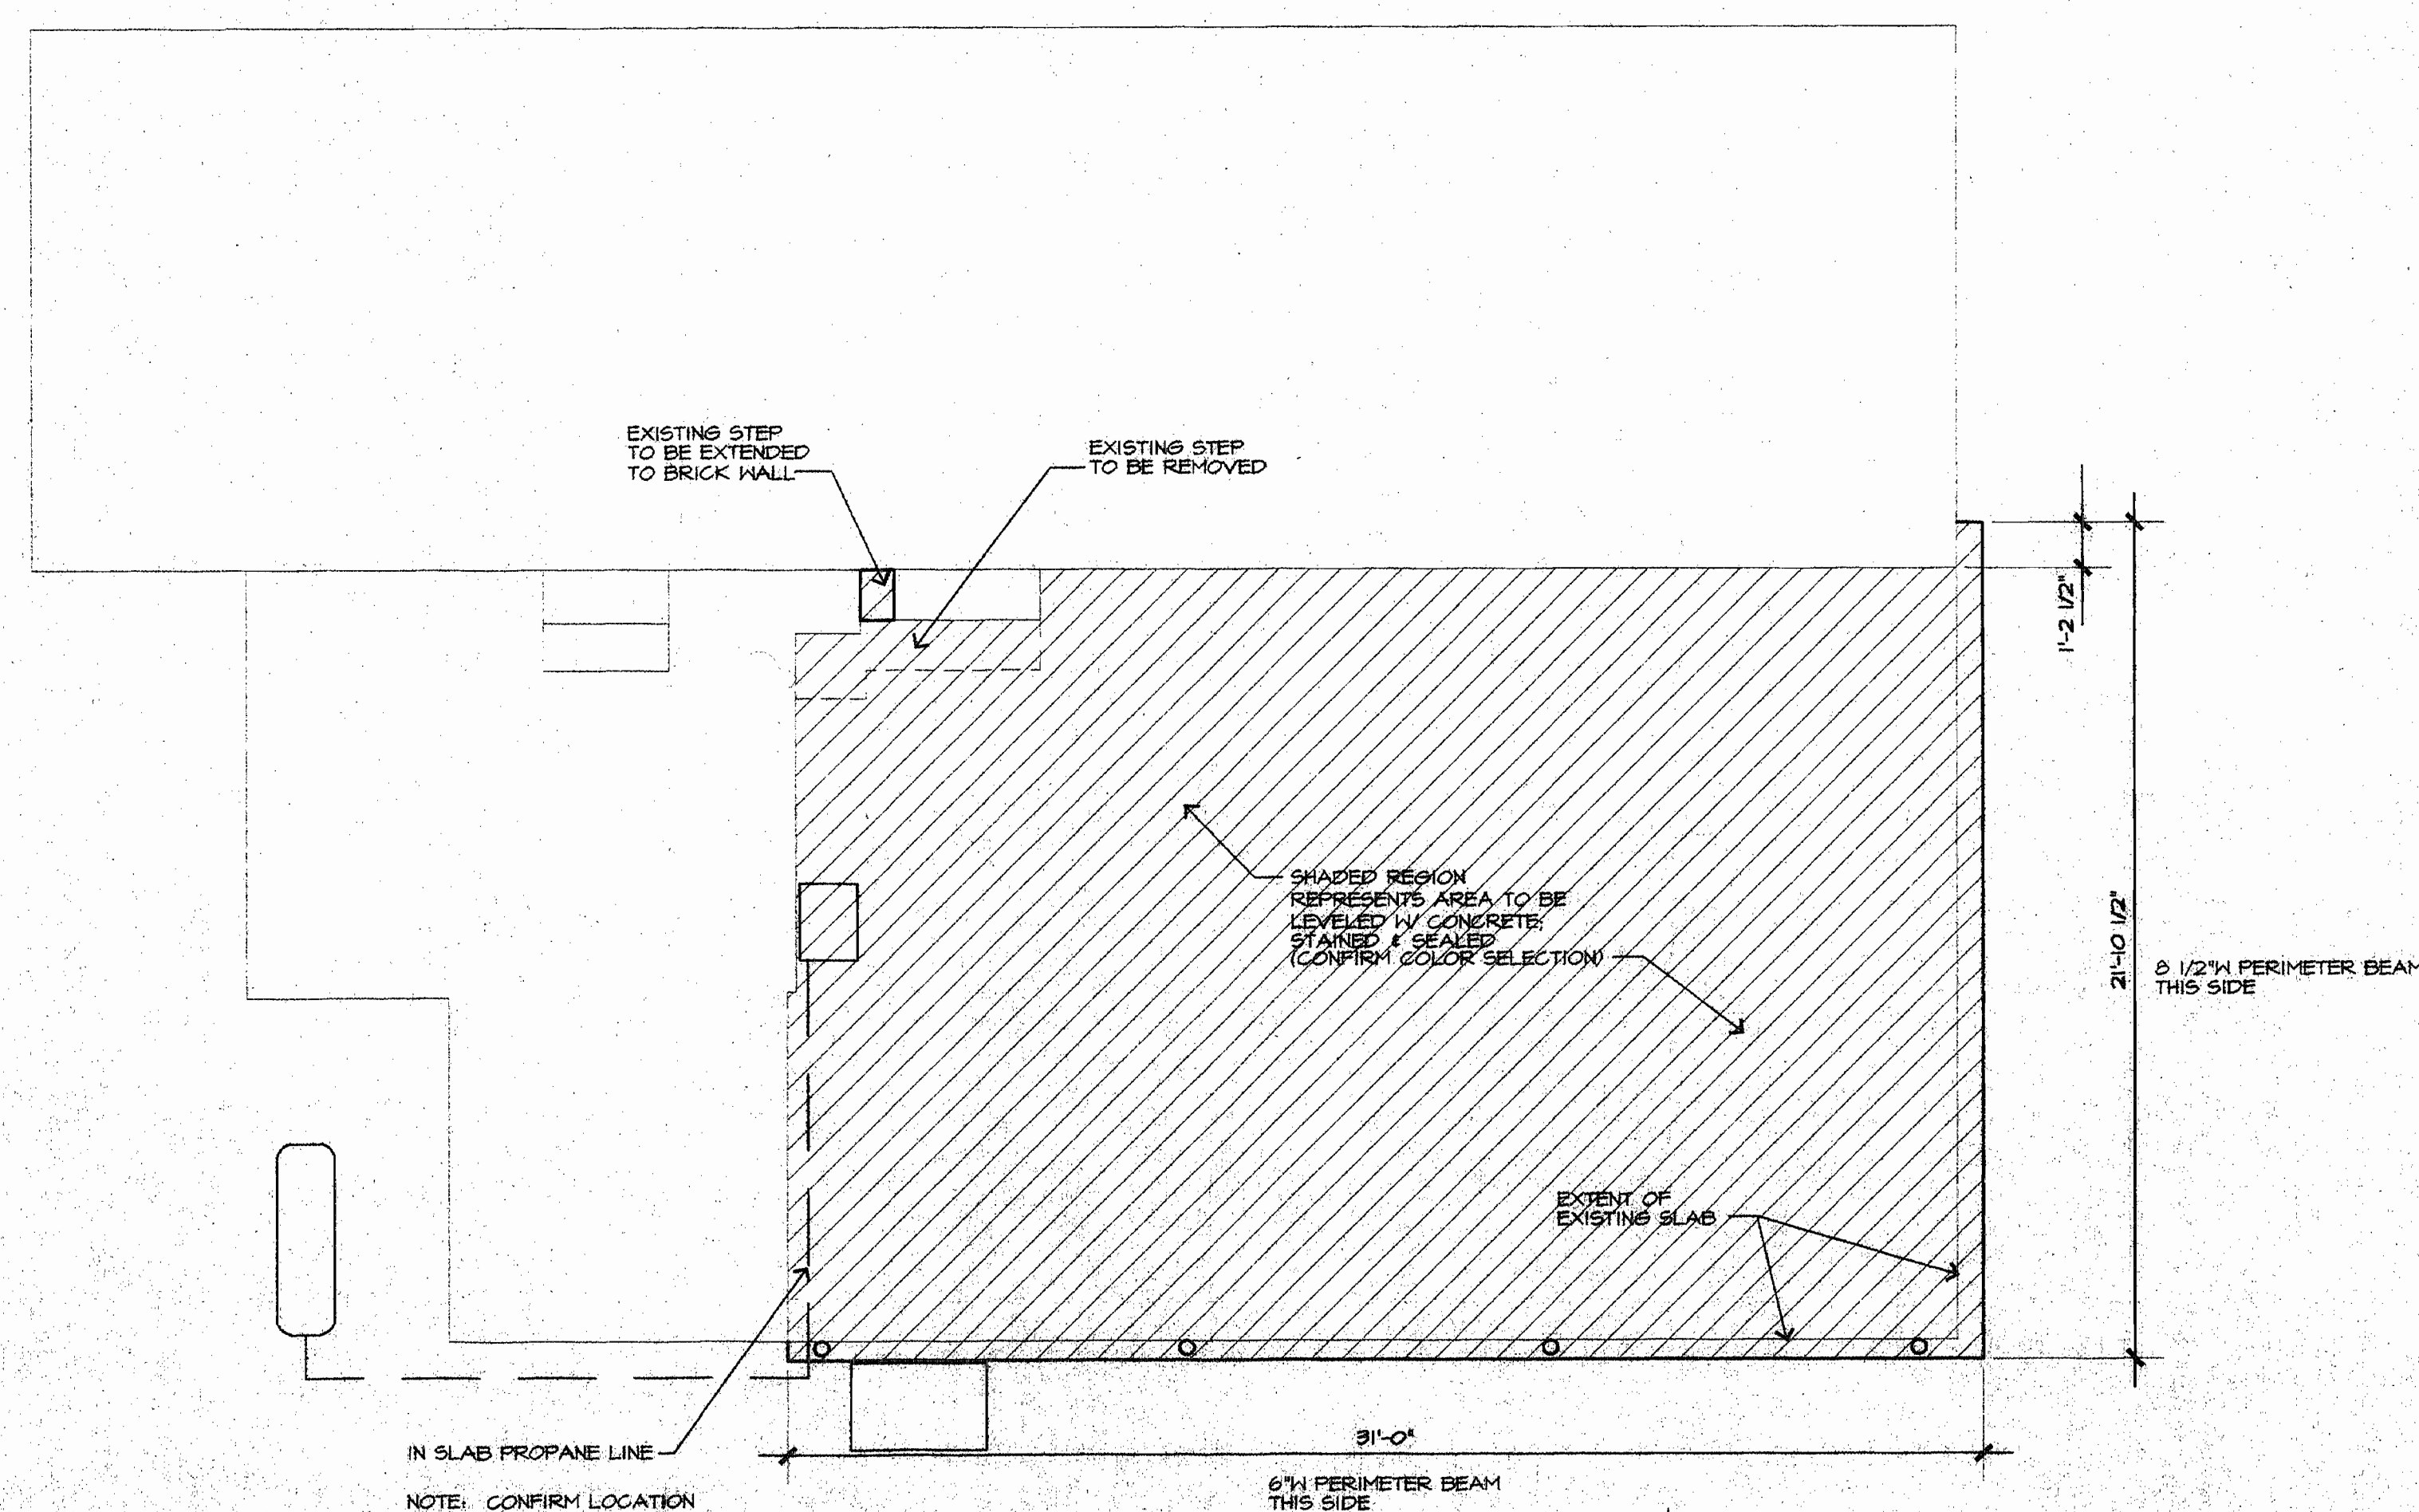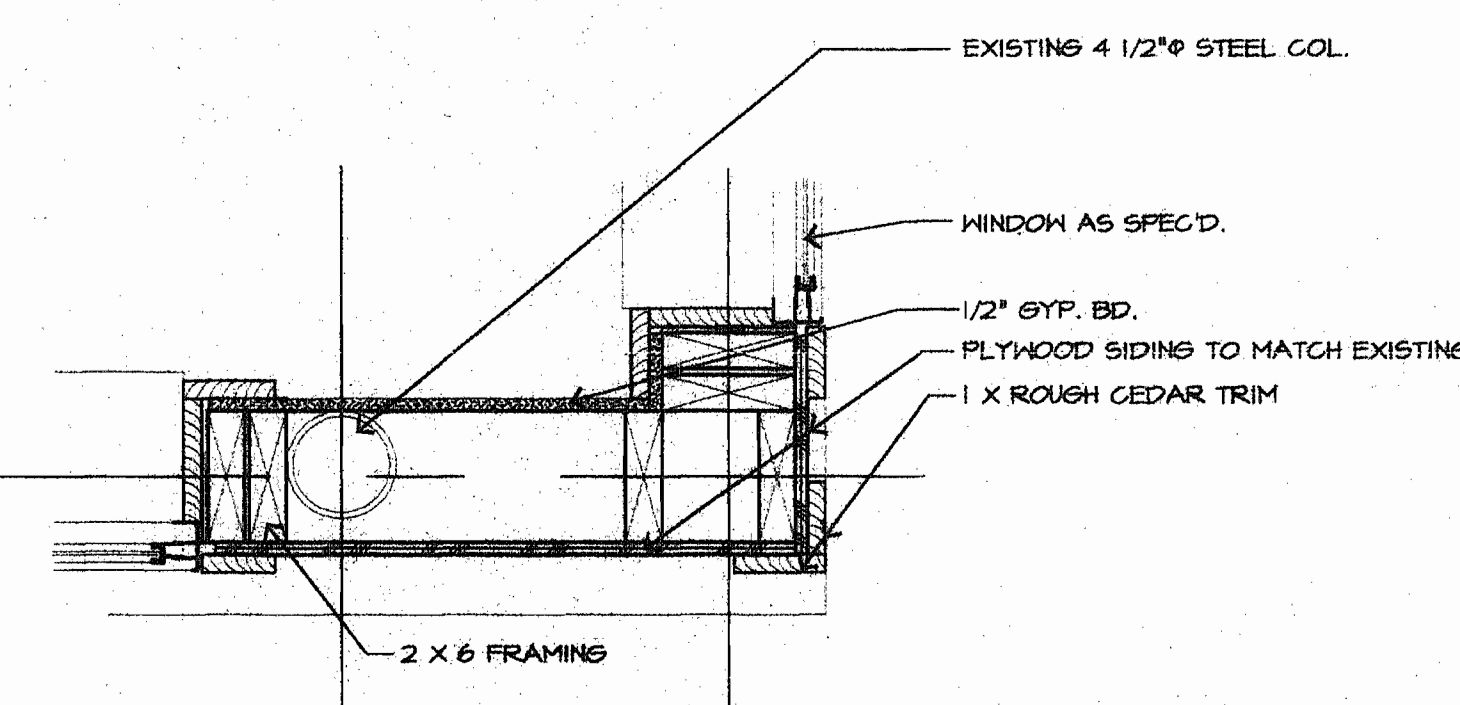

6 STRUCTURAL PLAN
SCALE: 1/4"

7 ELECTRICAL PLAN
SCALE: 1/4"

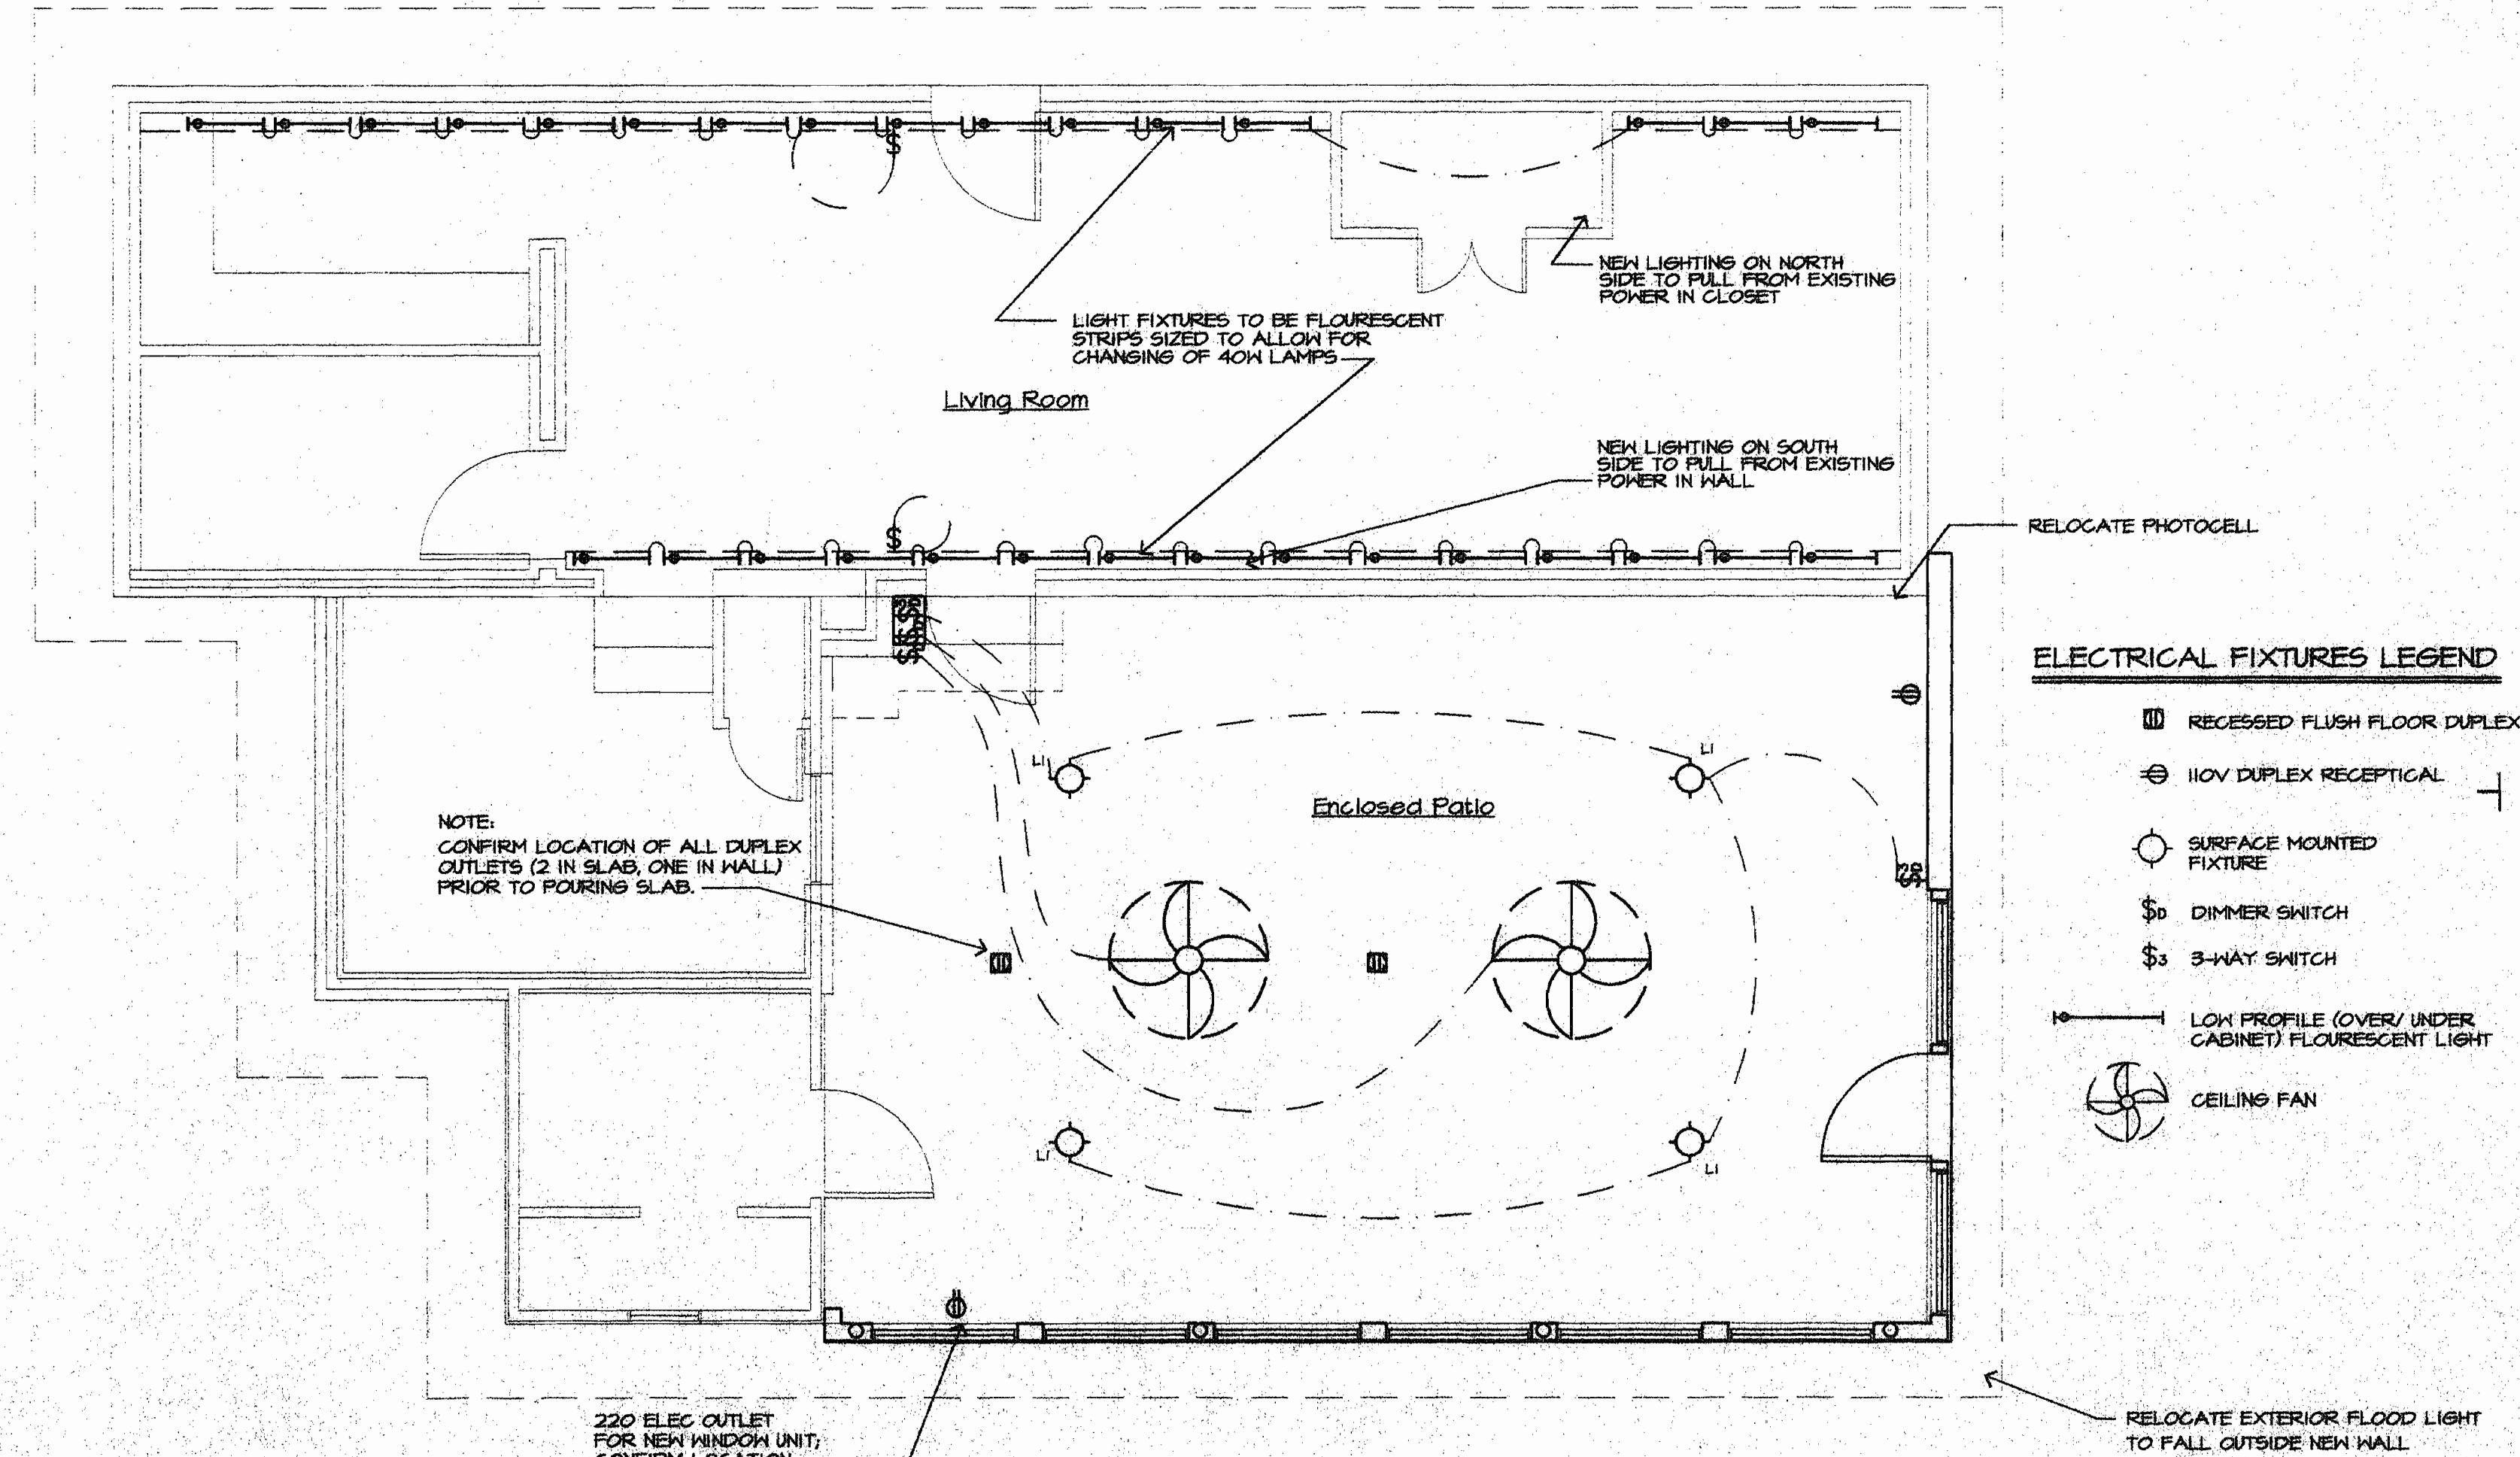


REVISIONS
ITEM/DATE/DESCRIPTION
4/14/00 KD




A Remodel for Mr. & Mrs. Sandell
MOUNTAIN HOME RD. INGRAM, TEXAS

PROJECT NO.	DATE
90710800	1/14/01

FLOOR PLAN
SHEET NUMBER
A2.0

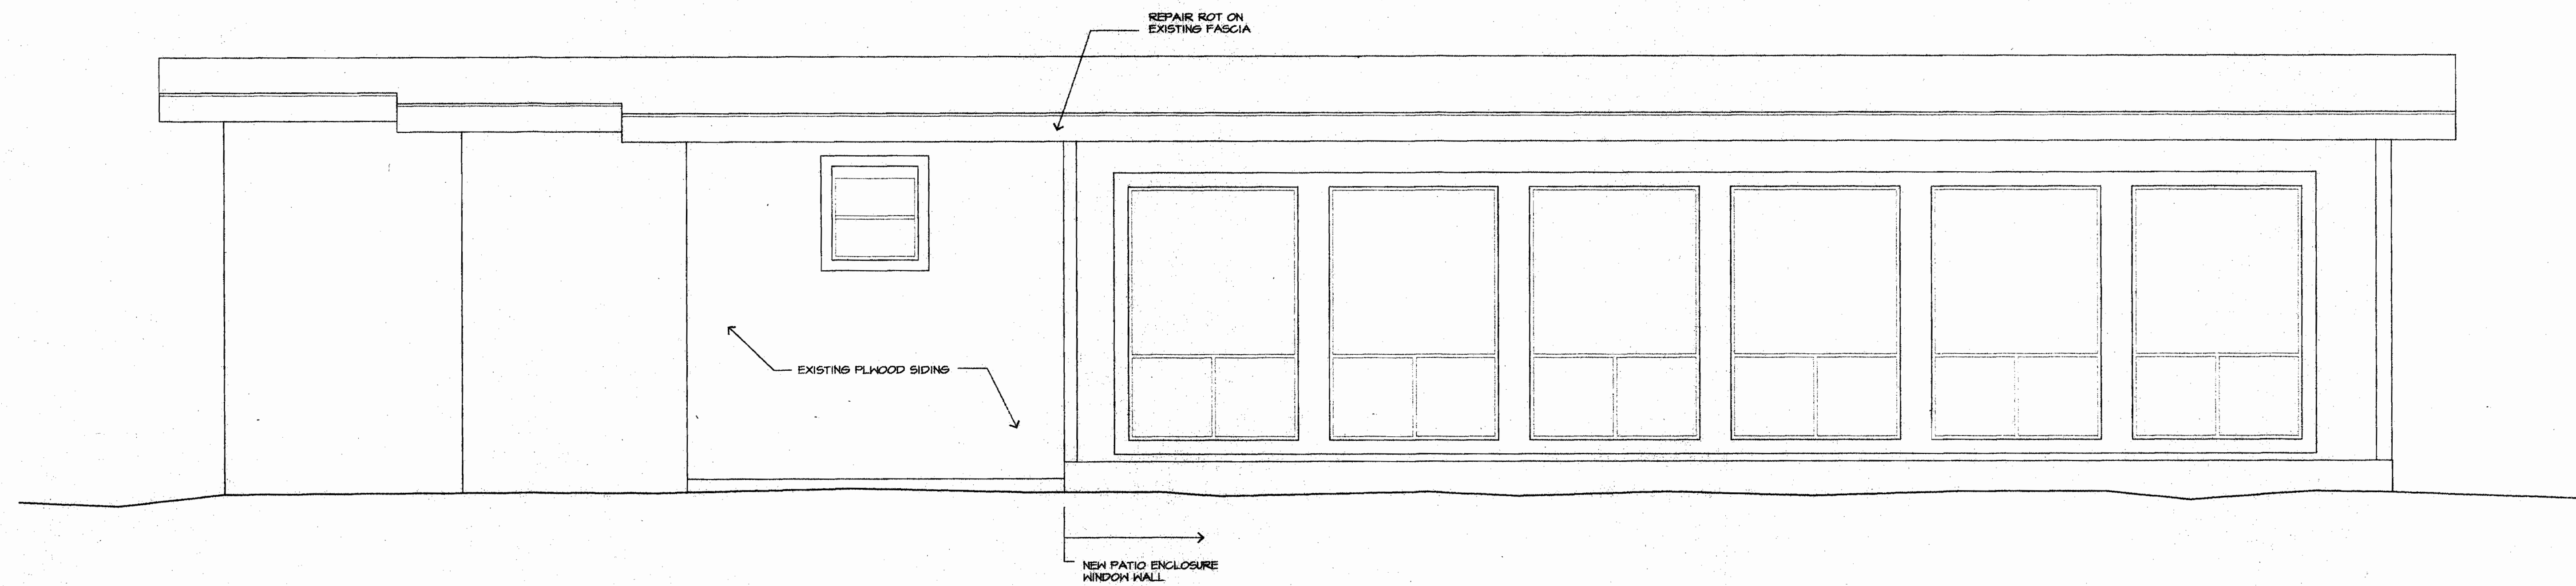

1 SOUTH ELEVATION
SCALE: 1/2"

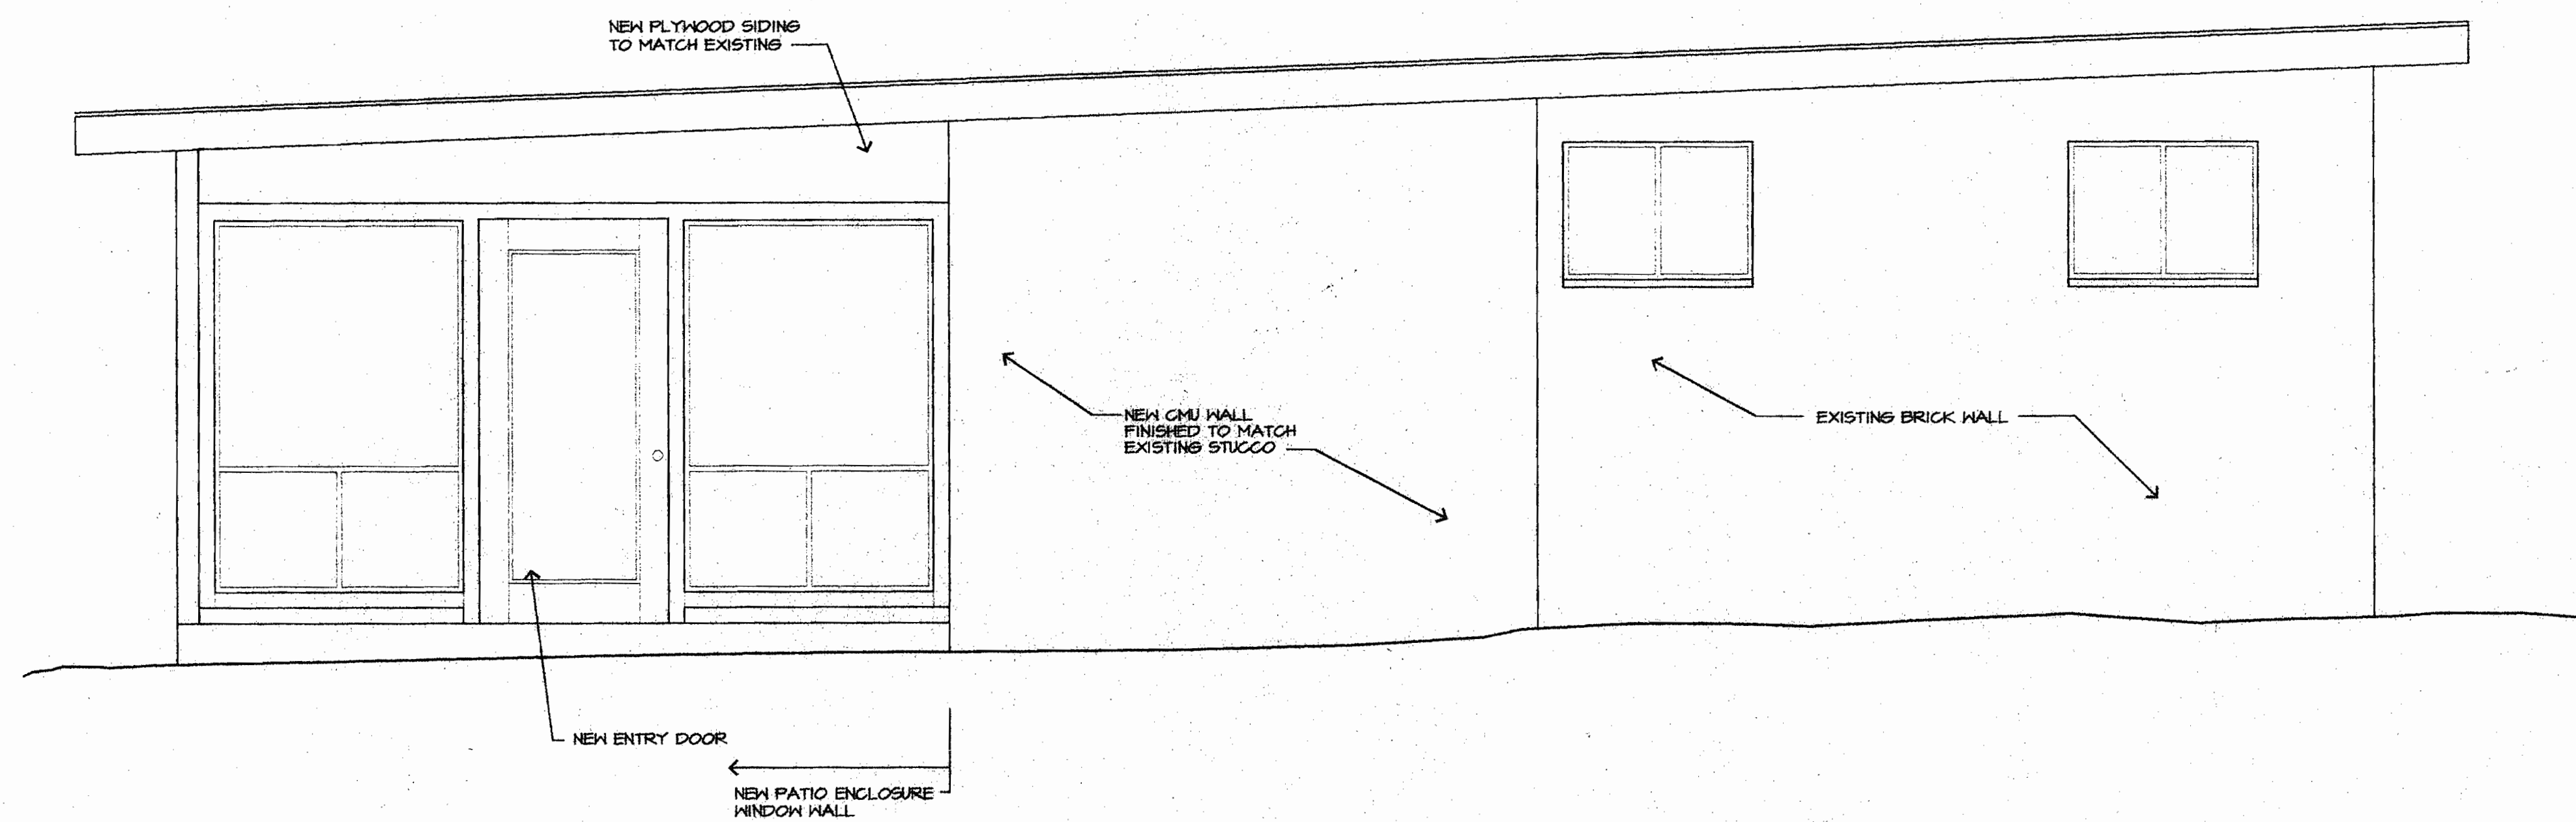

2 EAST ELEVATION
SCALE: 1/2"



826 Water Street Kerrville, Texas 78008
(210) 896-4220 Fax: (210) 896-4226

A Remodel
for
Mr. & Mrs.
Sandell


MOUNTAIN HOME RD.
INGRAM, TEXAS

NOT PUBLISHED: ALL RIGHTS RESERVED BY ARCHITECT. DRAWINGS AND SPECIFICATIONS ARE PREPARED BY ARCHITECT AND ARE THE PROPERTY OF ARCHITECT. NO PART OF THIS DRAWING OR SPECIFICATION MAY BE REPRODUCED OR TRANSMITTED IN ANY FORM OR BY ANY MEANS, ELECTRONIC OR MECHANICAL, WITHOUT PERMISSION IN WRITING FROM ARCHITECT.


PROJECT NO. DATE
10710200 1/6/91

EXTERIOR
ELEVATIONS

SHEET NUMBER
A3.0

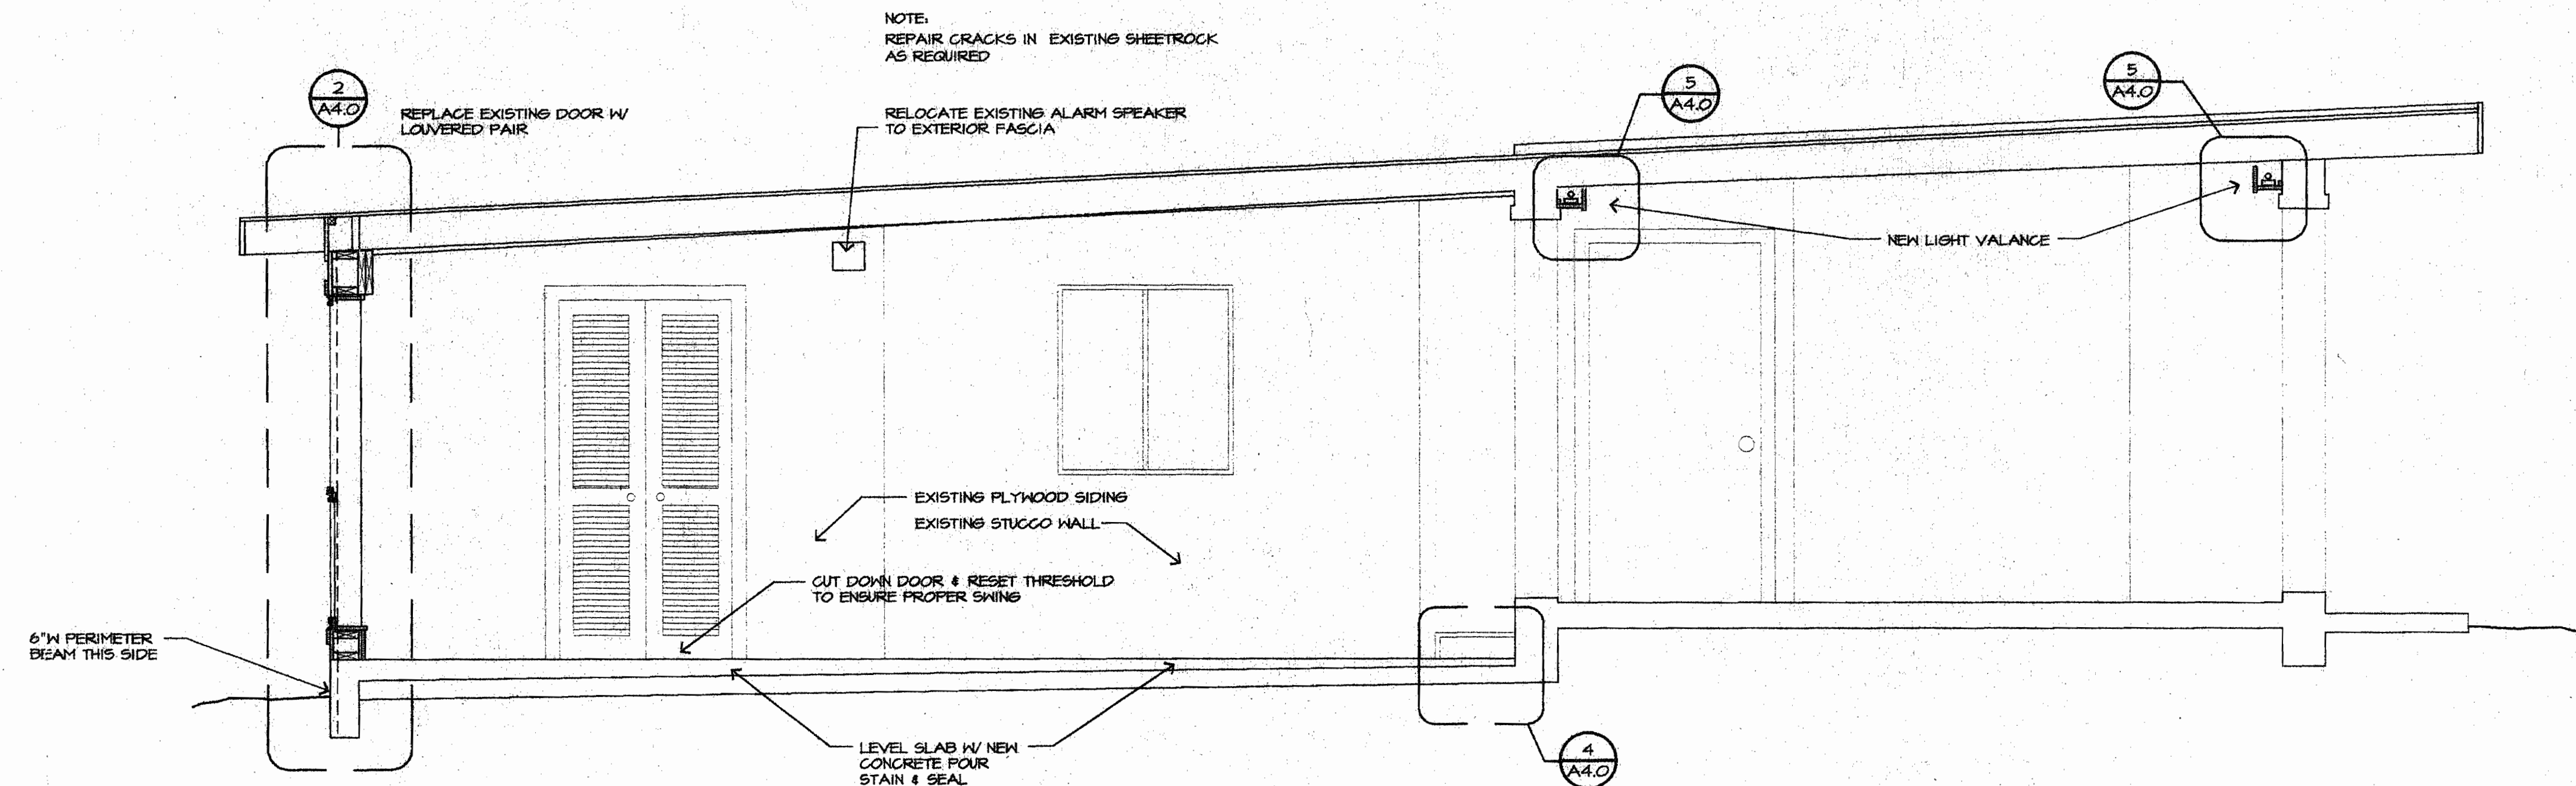


1 BUILDING SECTION
SCALE: 1/2"

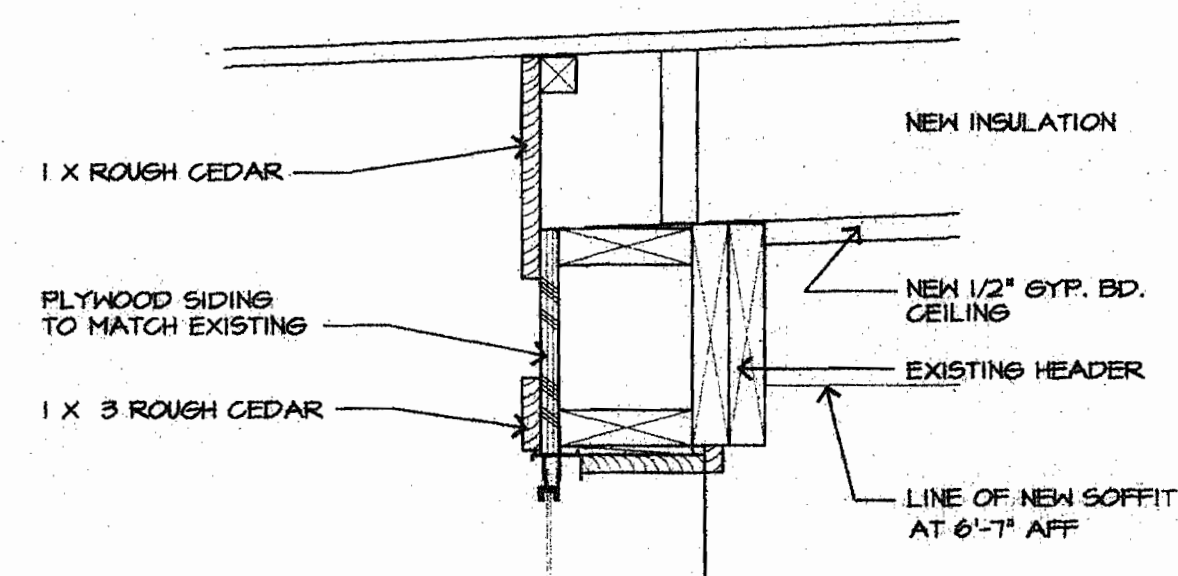


3 WALL SECTION
SCALE: 1 1/2"

2 NOT USED
SCALE: 3"

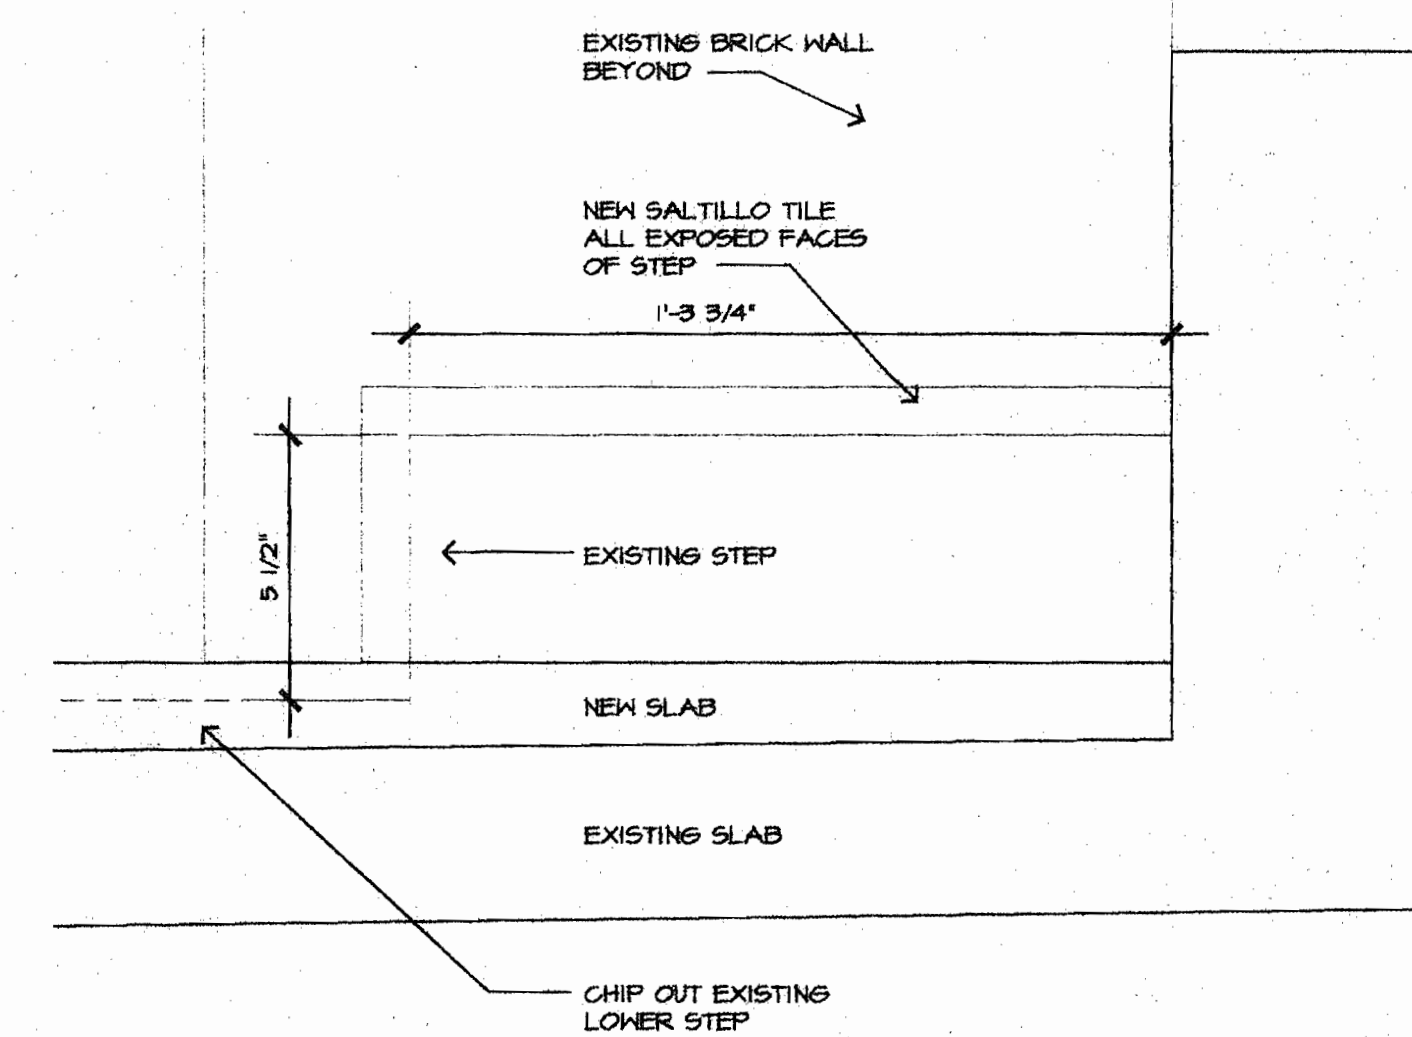

4 STAIR SECTION
SCALE: 3"

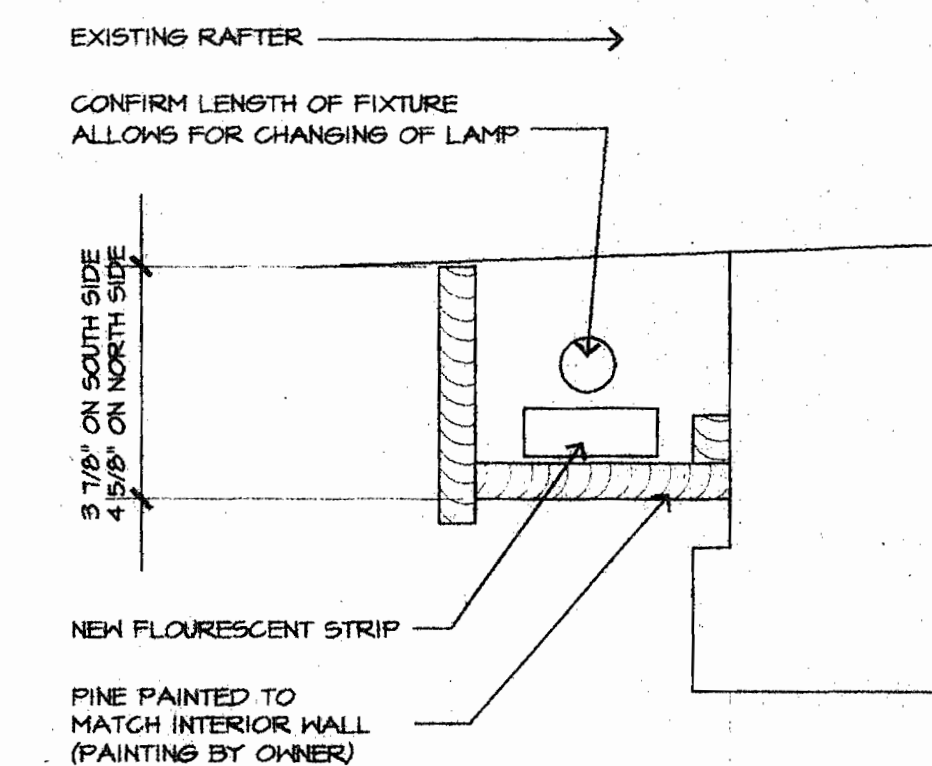

5 VALANCE SECTION
SCALE: 3"



824 Water Street, Kerrville, Texas 78008
(810) 896-4520 Fax (810) 896-4525

**A Remodel
for
Mr. & Mrs.
Sandell**

**MOUNTAIN HOME RD.
INGRAM, TEXAS**

NOT FOR CONSTRUCTION. ALL RIGHTS RESERVED BY ARCHITECT. CHANGES AND ADDITIONS TO BE MADE BY ARCHITECT. NO PART OF THIS DOCUMENT IS TO BE REPRODUCED OR TRANSMITTED IN ANY FORM OR BY ANY MEANS, ELECTRONIC OR MECHANICAL, INCLUDING PHOTOCOPYING, RECORDING, OR BY ANY INFORMATION STORAGE AND RETRIEVAL SYSTEM. WITHOUT PERMISSION IN WRITING FROM THE ARCHITECT. THIS DOCUMENT IS THE PROPERTY OF THE ARCHITECT AND IS TO BE USED ONLY FOR THE PROJECT AND SITE SPECIFICALLY IDENTIFIED HEREIN. IT IS NOT TO BE USED FOR ANY OTHER PROJECT OR SITE WITHOUT THE WRITTEN PERMISSION OF THE ARCHITECT. ANY VIOLATION OF THESE TERMS SHALL BE CONSIDERED A BREACH OF CONTRACT AND SUBJECT TO LEGAL ACTION.

PROJECT NO. DATE
90710800 1/6/91

**SECTIONS &
DETAILS**

SHEET NUMBER
A4.0