



HALSTEAD RANCH SITE PLAN 68718 VINEYARD CANYON ROAD PARKFIELD, CALIFORNIA 93451 PARCEL # 423-161-04E 000

RECORD OF SURVEY
LOTS 2 AND 3, ALONG WITH A
PORTION OF THE NE 1/4 OF THE SW 1/4, AND
A PORTION OF THE EAST 1/2 OF THE NW 1/4 OF
SECTION 18, TOWNSHIP 23 SOUTH, RANGE 14 EAST
MOUNT DIABLO BASE AND MERIDIAN
COUNTY OF MONTEREY, STATE OF CALIFORNIA

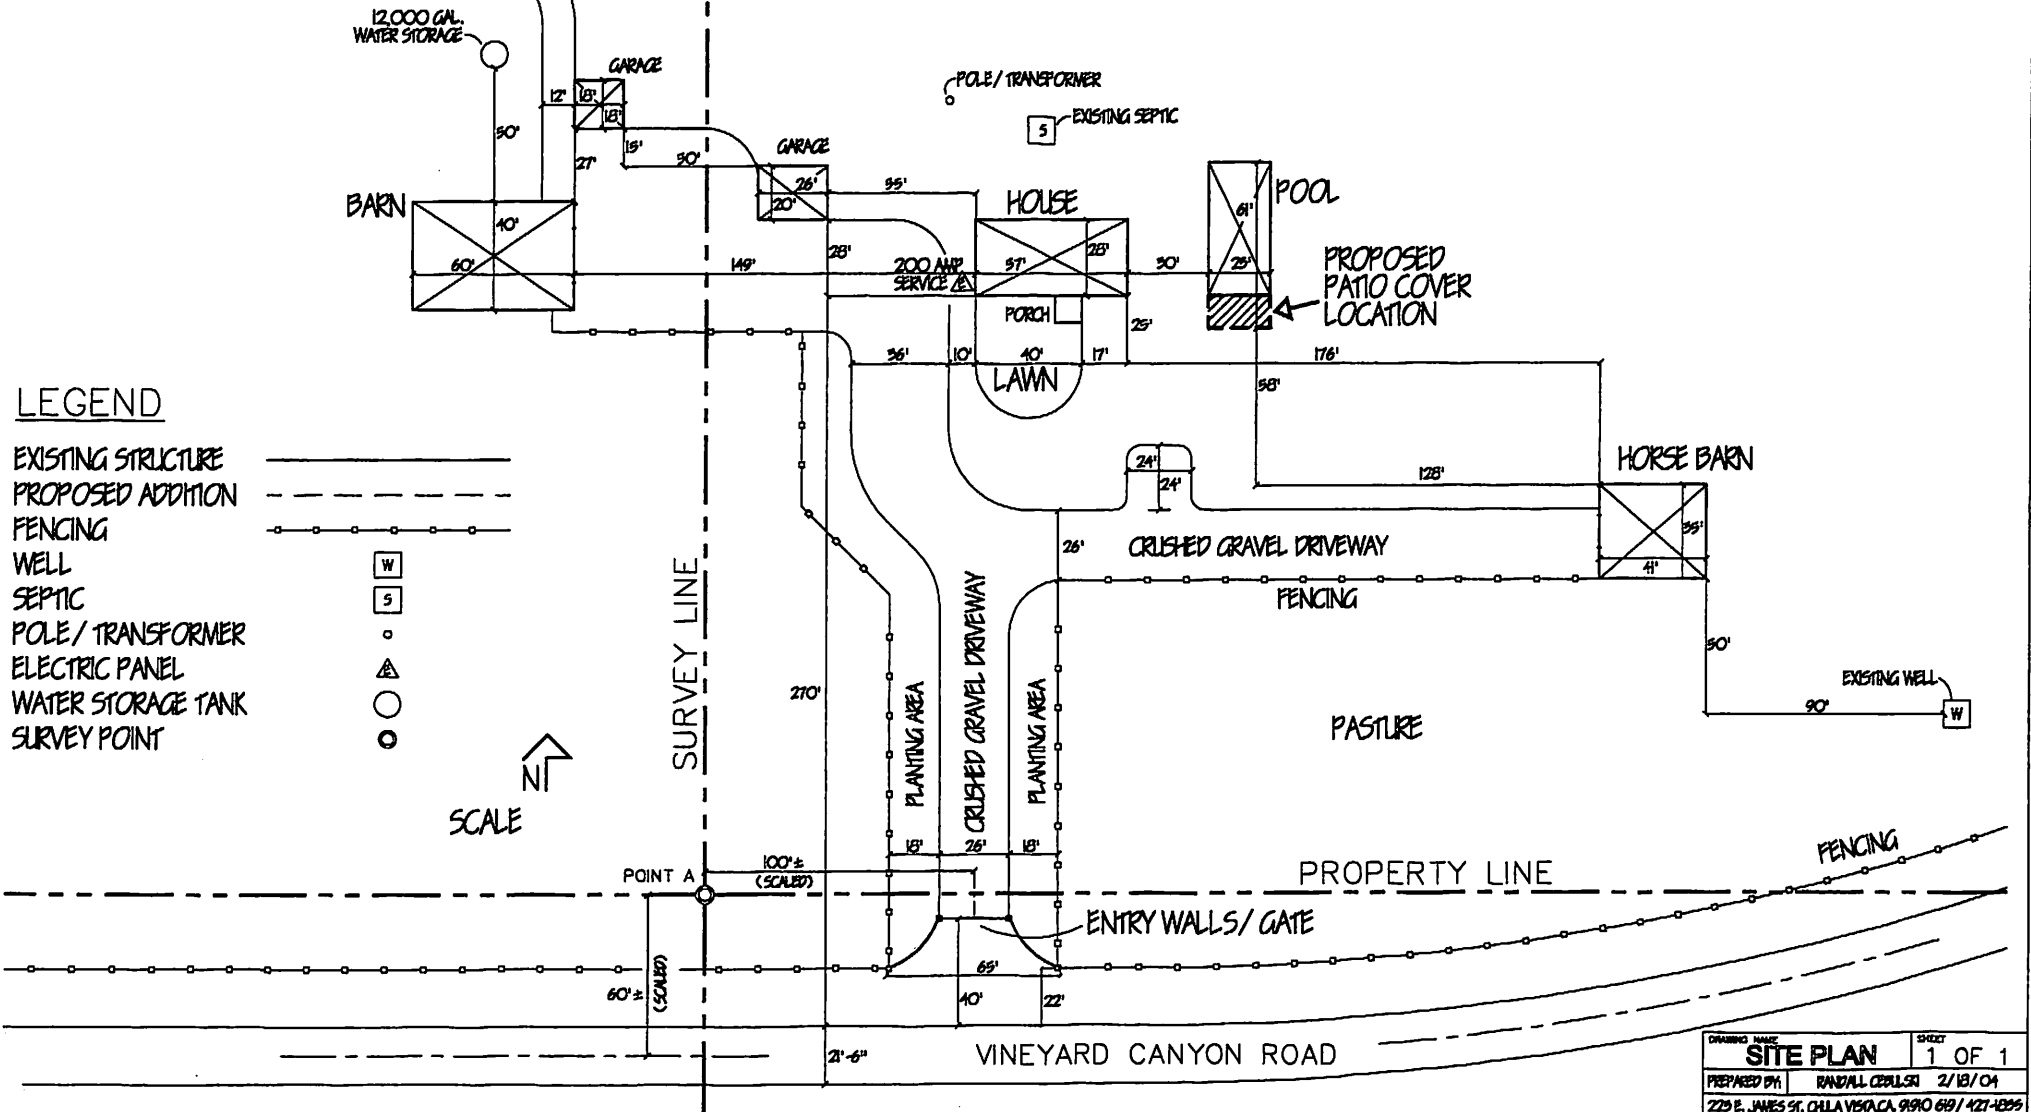

DRAWING NAME	SITE PLAN	SHEET	1 OF 1
PREPARED BY	RANDALL CRULLER	DATE	2/18/04
225 E. JAMES ST. CHULA VISTA, CA 91910 619 / 421-1895			

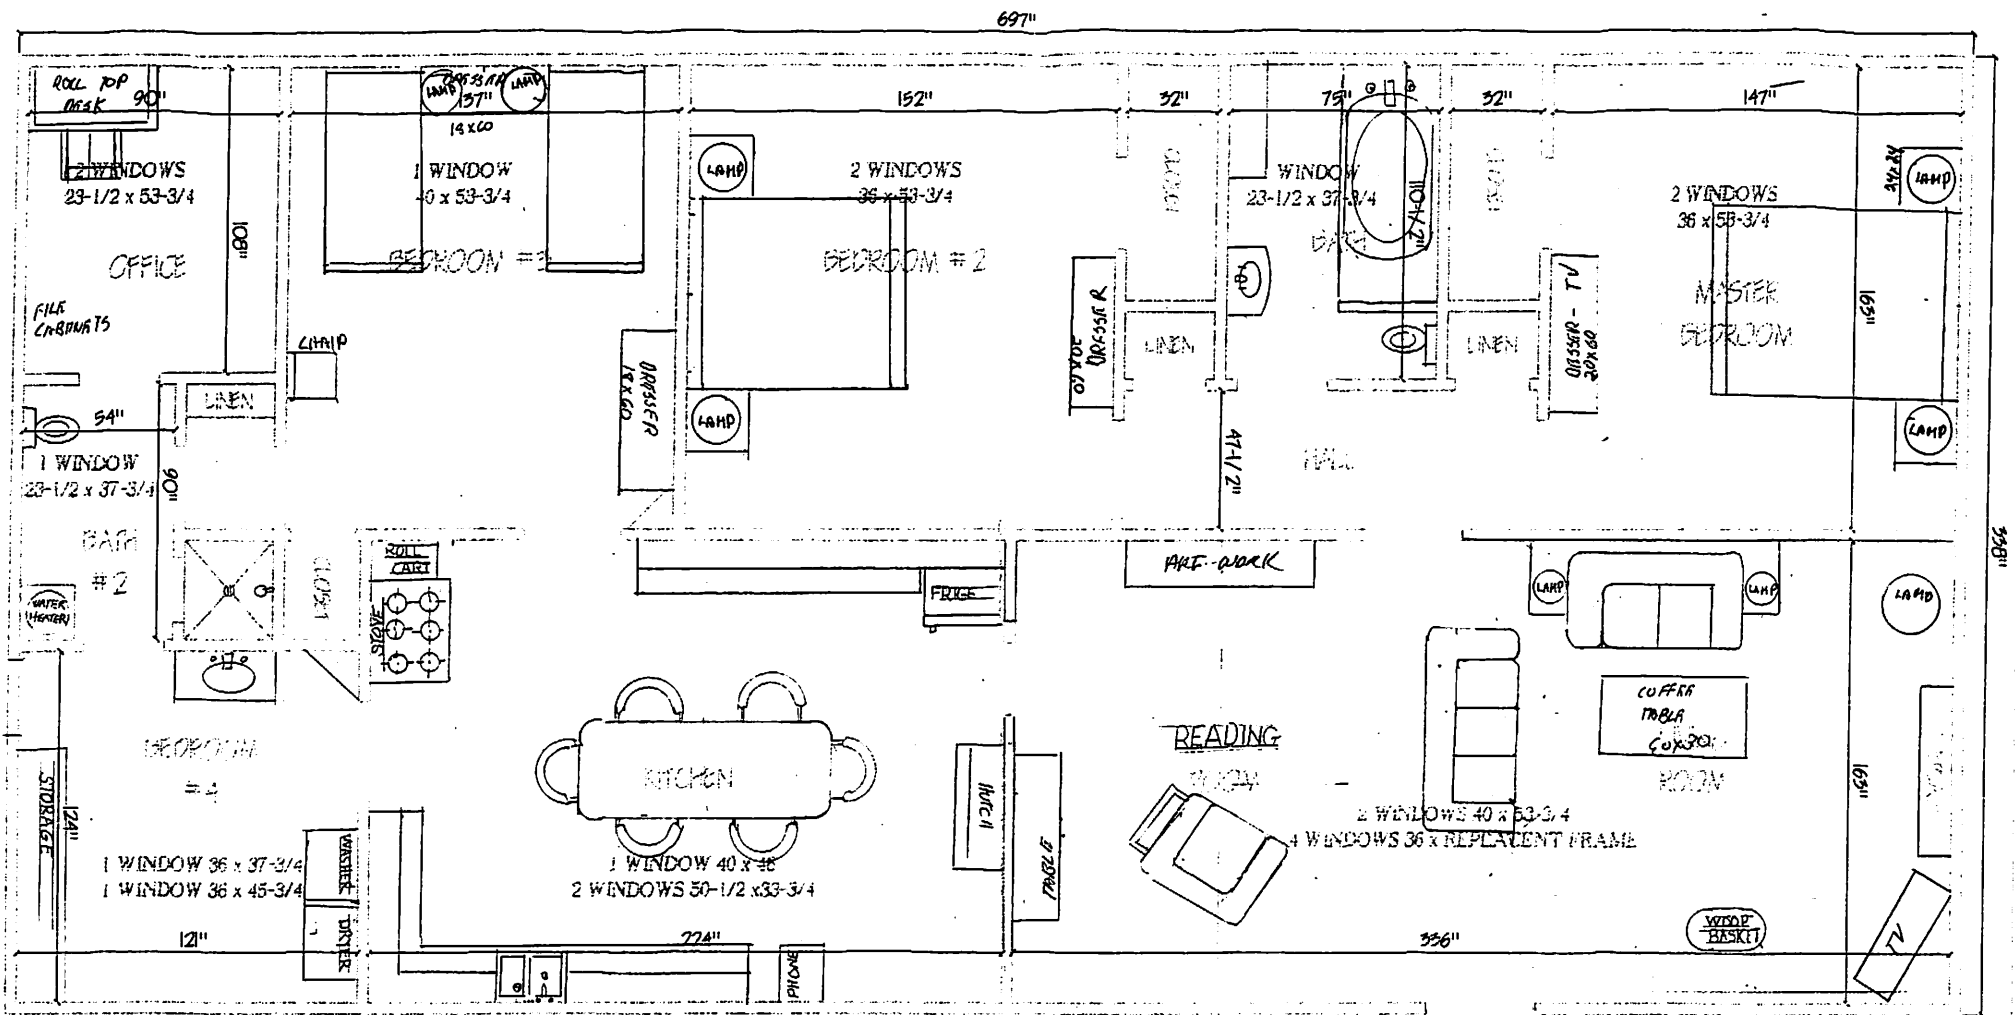

11/25/02

SCALE: 1/4" = 1'

APPROX 1,596. #

HALSTEAD RANCH HOUSE/PLAN VIEW

68718 VINEYARD CANYON ROAD
PARKFIELD, CALIFORNIA 93451





Date: 11-15-01

Customer: John Halstead
Address: 1236 Skylark Drive
La Jolla, CA 92037

Job Location : 68718 Vineyard Cyn Rd, San Miguel

Duration of Test: 4 Hours

H.P. of Pump in Well: 1 hp

Water Sample: (yes) (no) **Type:** (Gen. Mineral) (Bact.)

Lab: San Luis Obispo County Health Department

Meter Reading at Start of Test: 37260

GPM at Start of Test: 24

Time at Start of Test: 8:45 AM

Meter Reading at End of Test: 42810

GPM at End of Test: 23

Time at End of Test: 12:45 PM

Total Time of Test in Minutes: 240 minutes

Total Gallons Pumped During Test: 5550 gallons

Average 23.125 **gallons per minute for 4 hours**

Thank you for allowing Aqua Engineering the opportunity to test your water well. If you have any questions regarding your test, please don't hesitate to call.

N. Rex Awalt
Aqua Engineering