


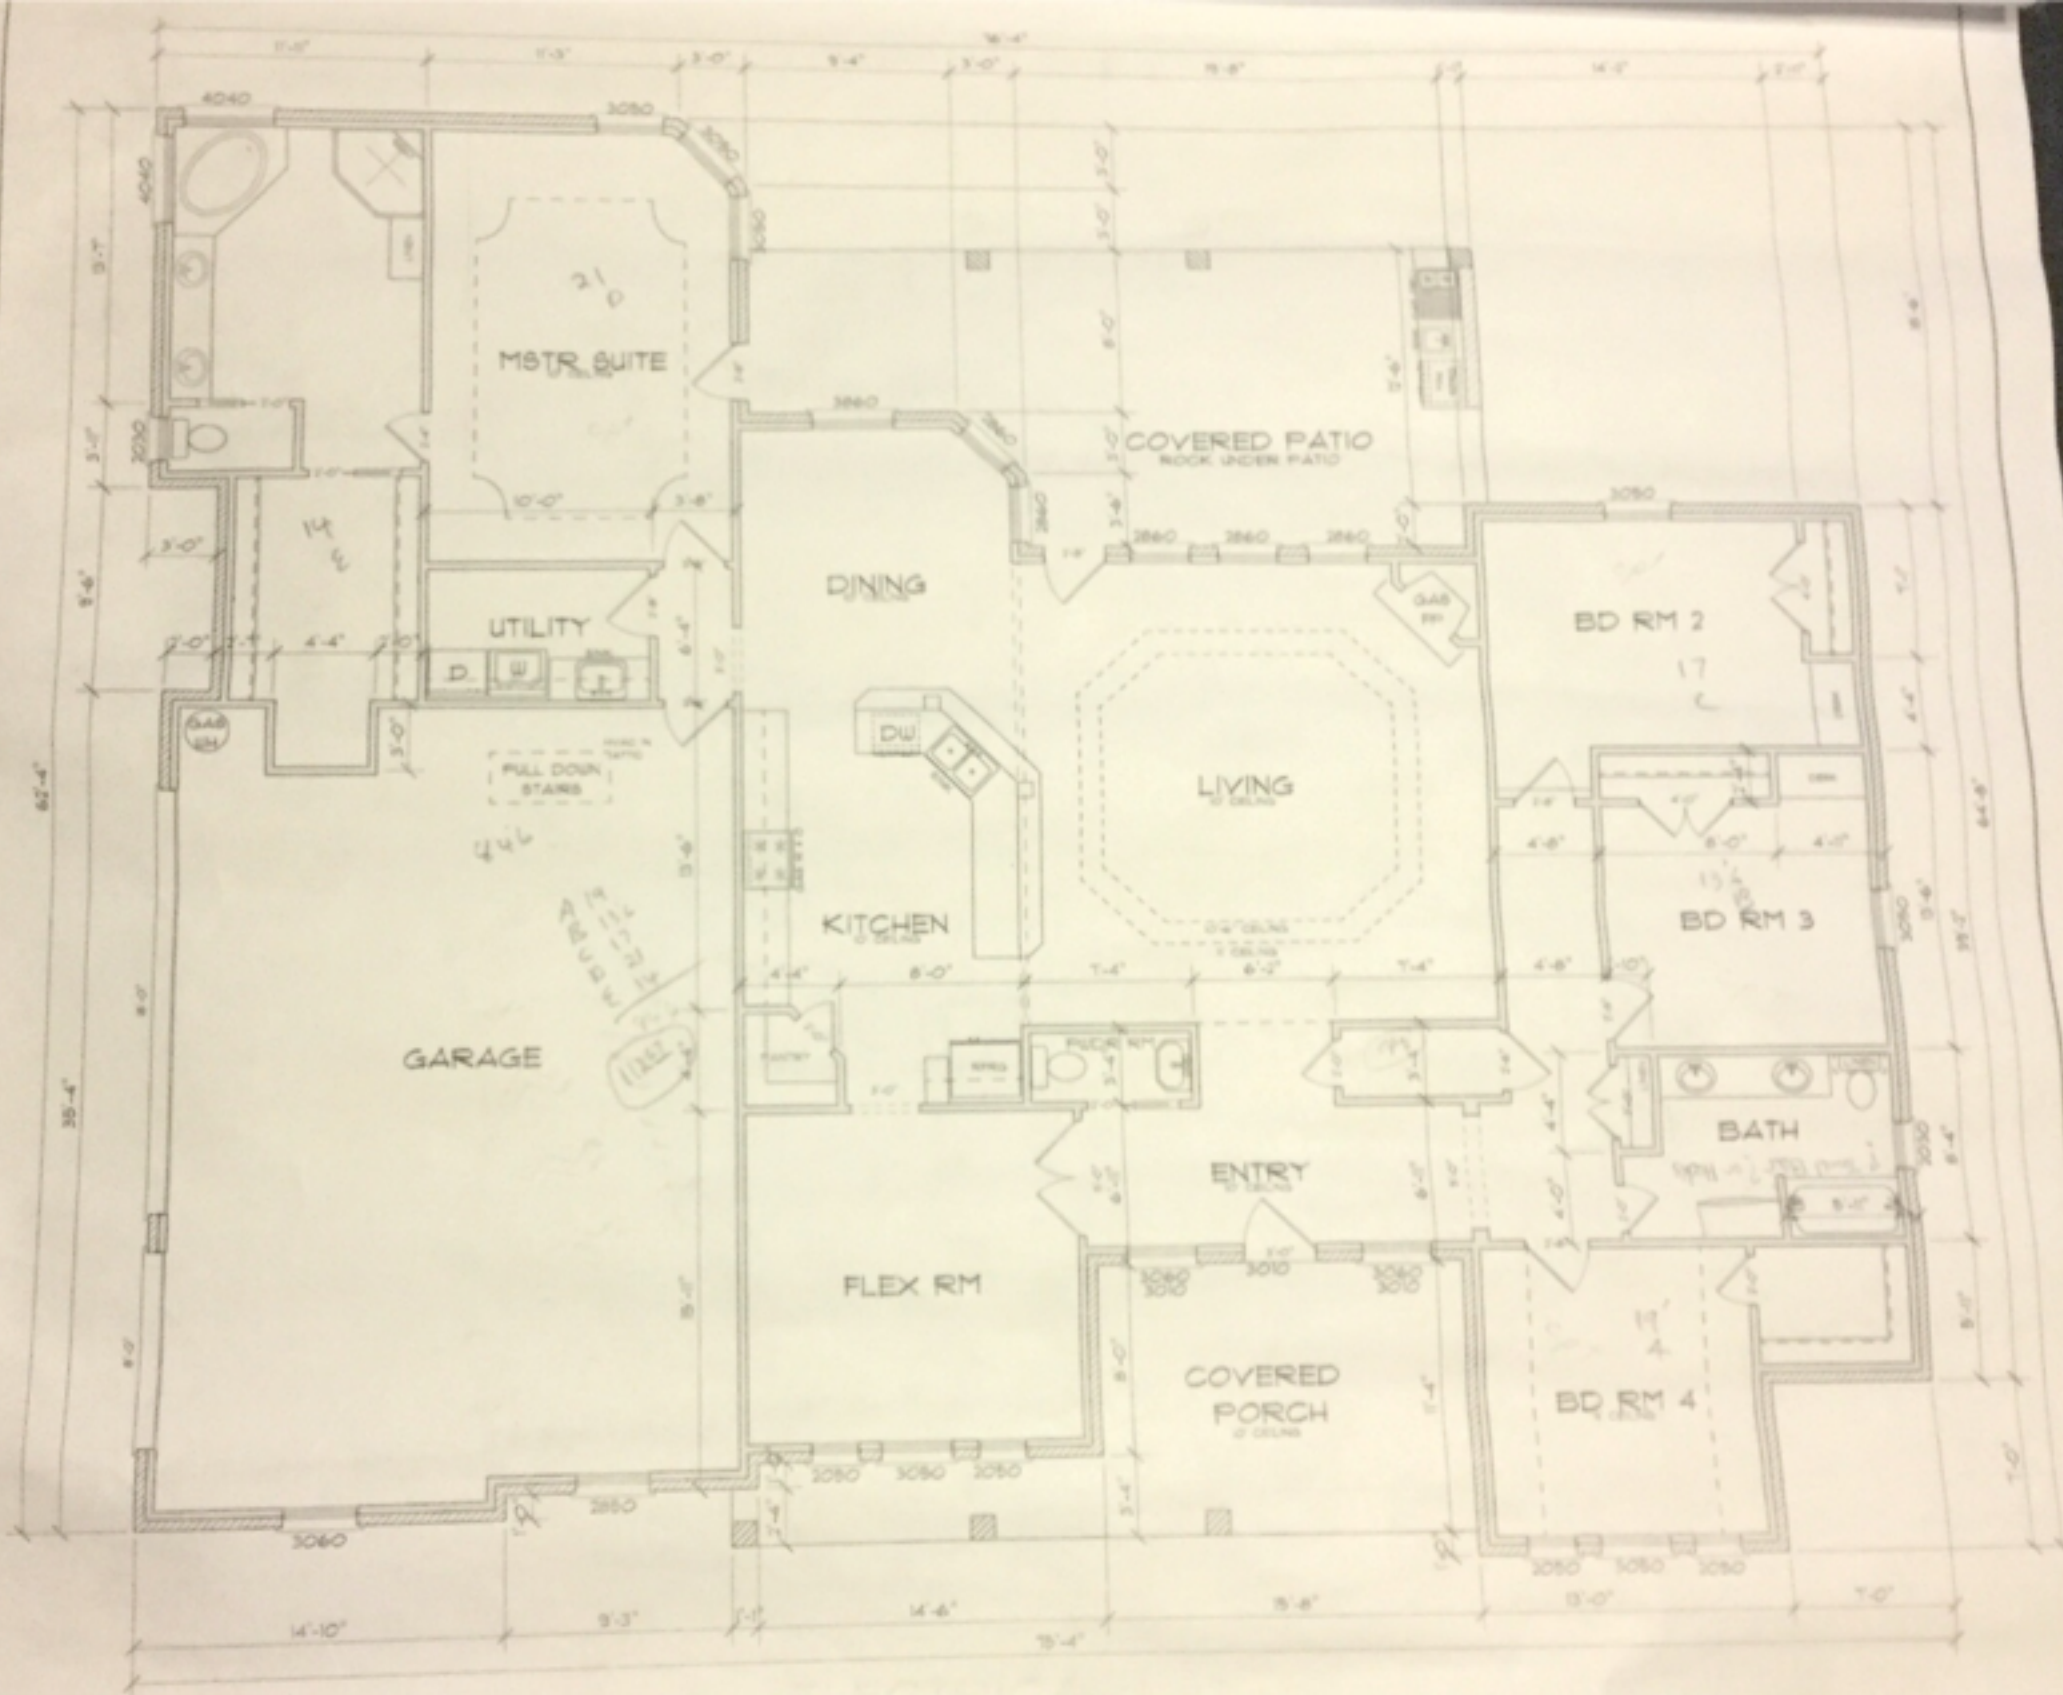


FLOOR PLAN

SCALE: 1/4" = 1'-0"

AREA

LIVING	2782
GARAGE	622
POR/PATIO	631

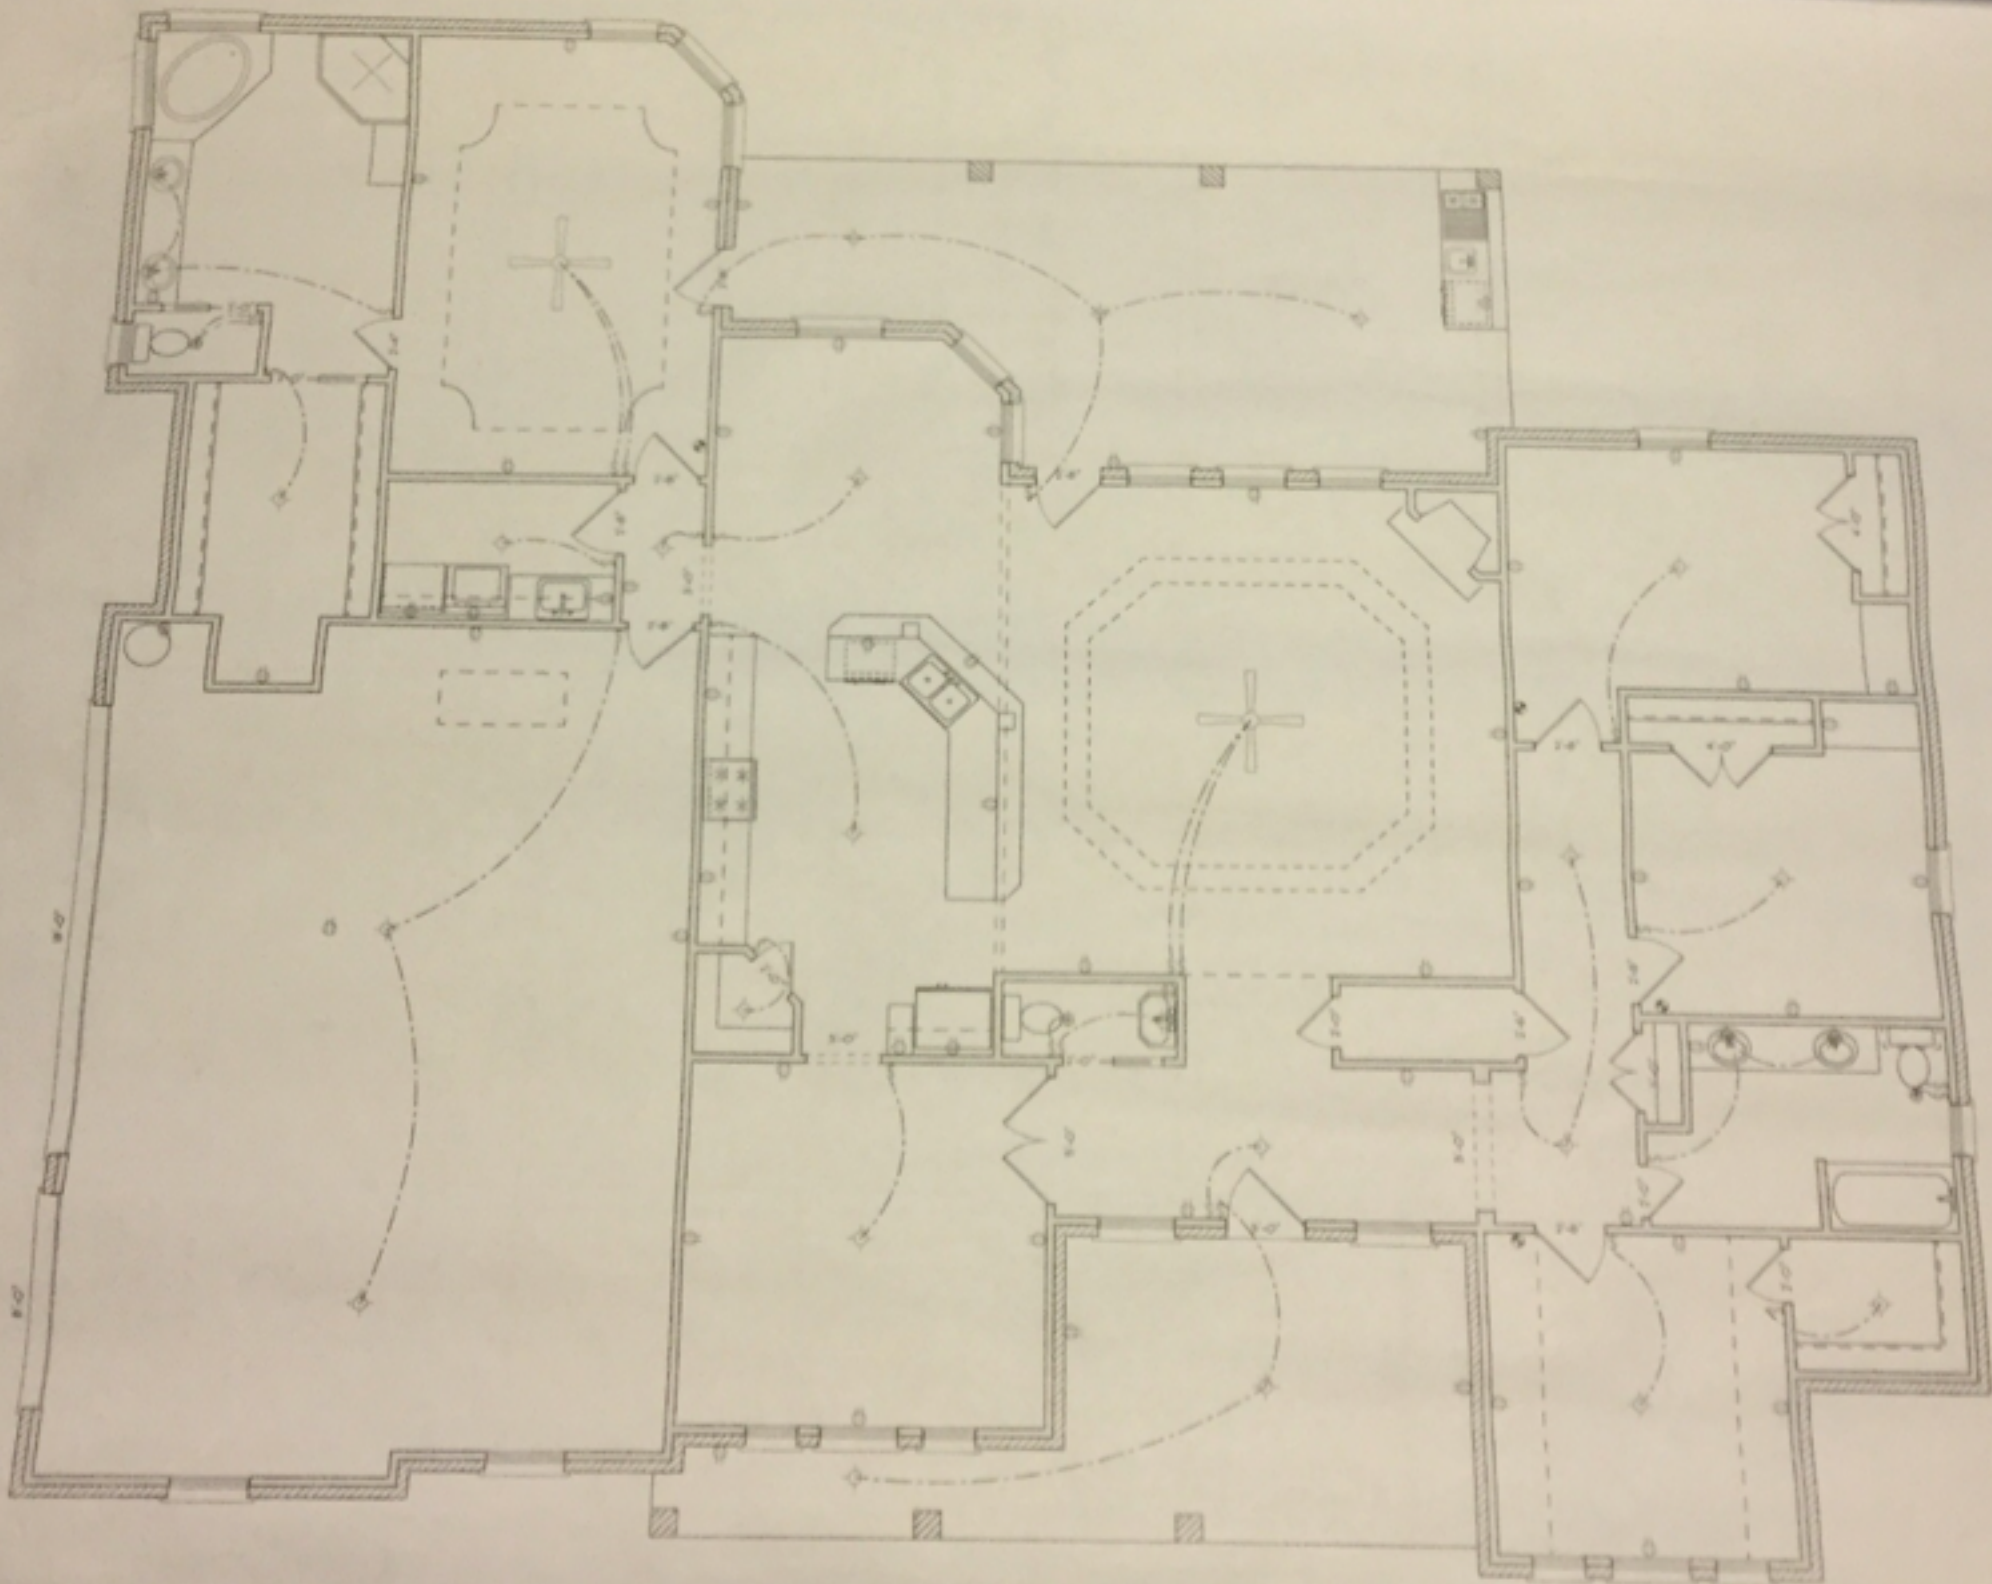

ELECTRICAL LAYOUT

SCALE: 1/4" = 1'-0"

ALL WIRING TO BE AS PER 2008 NEC
AND LOCAL CITY ELECTRICAL CODE
NOTE: NO MORE THAN 8 OUTLETS PER
CIRCUIT, OUTLETS TO BE A MIN. 5' APP.
GFI AS REQUIRED BY NEC 2008



FRONT ELEVATION

SCALE: 1/4" = 1'-0"