

DOOR AND WINDOW SIZE KEY
2860 = 2'-8" WIDE x 6'-0" HIGH

DOOR AND WINDOW SIZE KEY
2860 = 2'-8" WIDE x 6'-0" HIGH

DRAWING NUMBER  = SECTION OR ELEVATION

A diagram of a kitchen layout. The word "KITCHEN" is centered at the top. Below it, "10' CLG." is on the left and "WOOD" is on the right. At the bottom, "CEILING HEIGHT" is on the left and "FLOOR FINISH" is on the right. Lines connect the labels to the corresponding parts of the kitchen: "SHEET NUMBER" points to the top left corner, "ROOM TITLE" points to "KITCHEN", "CEILING HEIGHT" points to "10' CLG.", and "FLOOR FINISH" points to "WOOD".

1 DRAWING TITLE

DETAIL OR ELEVATION NUMBER

14.00' — ELEVATION ABOVE SEA LEVEL


 NATIONAL BUREAU OF STANDARDS

1 = REVISION NUMBER

 REVISION CLOUD = PLAN REFERENCE NORTH

	SINGLE POLE SWITCH
	THREE WAY SWITCH
	FOUR WAY SWITCH
	DIMMER SWITCH
	SPEED CONTROL
	DUPLEX OUTLET
	1/2 HOT OUTLET
	WATER PROOF OUTLET
	GROUND FAULT OUTLET
	QUADPLEX OUTLET
	SPECIALTY OUTLET
	FLOOR OUTLET
	TELEPHONE JACK
	THERMOSTAT
	TELEVISION JACK
	VENT
	VENT w/ LIGHT
	SURFACE MOUNTED FIXTURE
	RECESSED FIXTURE
	WALL MOUNTED FIXTURE
	FLOOD LIGHT
	FLUORESCENT FIXTURE
	CEILING FAN
	STRIP LIGHTING
	CEILING BOX
	DOOR CHIME
	ELECTRICAL PANEL
	SMOKE DETECTOR
	CARBON MONOXIDE DETECTOR



CONCEPTUAL RENDERING

0	COVER SHEET
5	SITE PLAN
1	FOUNDATION PLAN
2	FIRST FLOOR + ROOF PLAN
3	ELEVATIONS
4	INTERIOR ELEVATIONS + BUILDING SECTION
5	WALL SECTION + DETAILS
6	ELECTRICAL PLAN
7	RIDING ARENA ELECTRICAL PLAN
SP1	SPECIFICATIONS
SP2	SPECIFICATIONS
SP3	SPECIFICATIONS

AREA CALCULATIONS

FIRST FLOOR HEATED = XXXX S.F.	GARAGE AND STORAGE = XXXX S.F.
SECOND FLOOR HEATED = XXXX S.F.	SCREENED PORCH = XXXX S.F.
TOTAL HEATED = XXXX S.F.	COVERED PORCH = XXXX S.F.

SANCTUARY STABLES

Copyright 2017 by Allison Ramsey Architects, Inc. All rights reserved.

 
 
 
 
DATE: 6/28/2017

JOB NO.	17201
---------	-------

DOWN. BY: RWM


DWG. NAME: 17201.DWG

0



3

Copyright 2017 by Allison Ramsey Architects, Inc. All rights reserved.

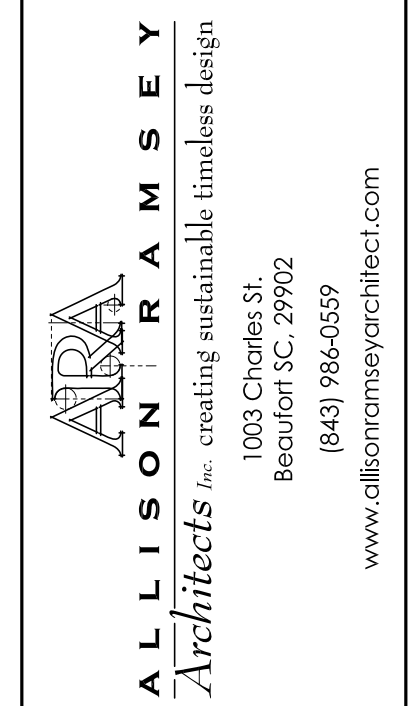

THIS PLAN HAS BEEN DESIGNED TO MEET THE PROFESSIONAL STANDARDS AND PRACTICES, POWER RATING CRITERIA AND ENVIRONMENTAL CONDITIONS THAT ARE APPLICABLE TO THE FOLLOWING LOCATIONS. IT IS THE RESPONSIBILITY OF THE MANAGER OF THIS PLAN TO REPORT THE FOLLOWING BEFORE BEING RE-CONSIDERED AGAIN: ARTIST'S INC. ASSURES NO LIABILITY FOR ANY OTHER CONSIDERATION ALLOWED BY THIS PLAN.

ARTIST ALL PERSONS WORK TO PROTECTING WITH CONSTRUCTION

ARTIST COMPLIANCE WITH ALL LOCAL CODES

PLANS INDICATE LOCATIONS ONLY, INDICATING ARTIST'S SHOULD INDICATE THE ACTUAL SITE CONDITIONS.





LOCAL PLANNING DEPARTMENT HAS NOT REVIEWED THESE, SHOULD BE OBTAINED FROM A LOCAL PLANNING DEPARTMENT OR IN ORDER TO OBTAIN COMPLIANCE WITH LOCAL CODE

AND THE CURRENT IS USED CURRENTLY FOR THIS PARTICULAR REGION AND CONDITIONS.


ARTIST ALL STRUCTURAL ELEMENTS WITH LOCAL INORDER ARTIST SHOULD BE OBTAINED

DATE:	6/28/2017
JOB NO.	17201
DWN. BY:	RWH
DWG. NAME:	17201.DWG

Copyright 2017 by Allison Ramsey Architects, Inc. All rights reserved.

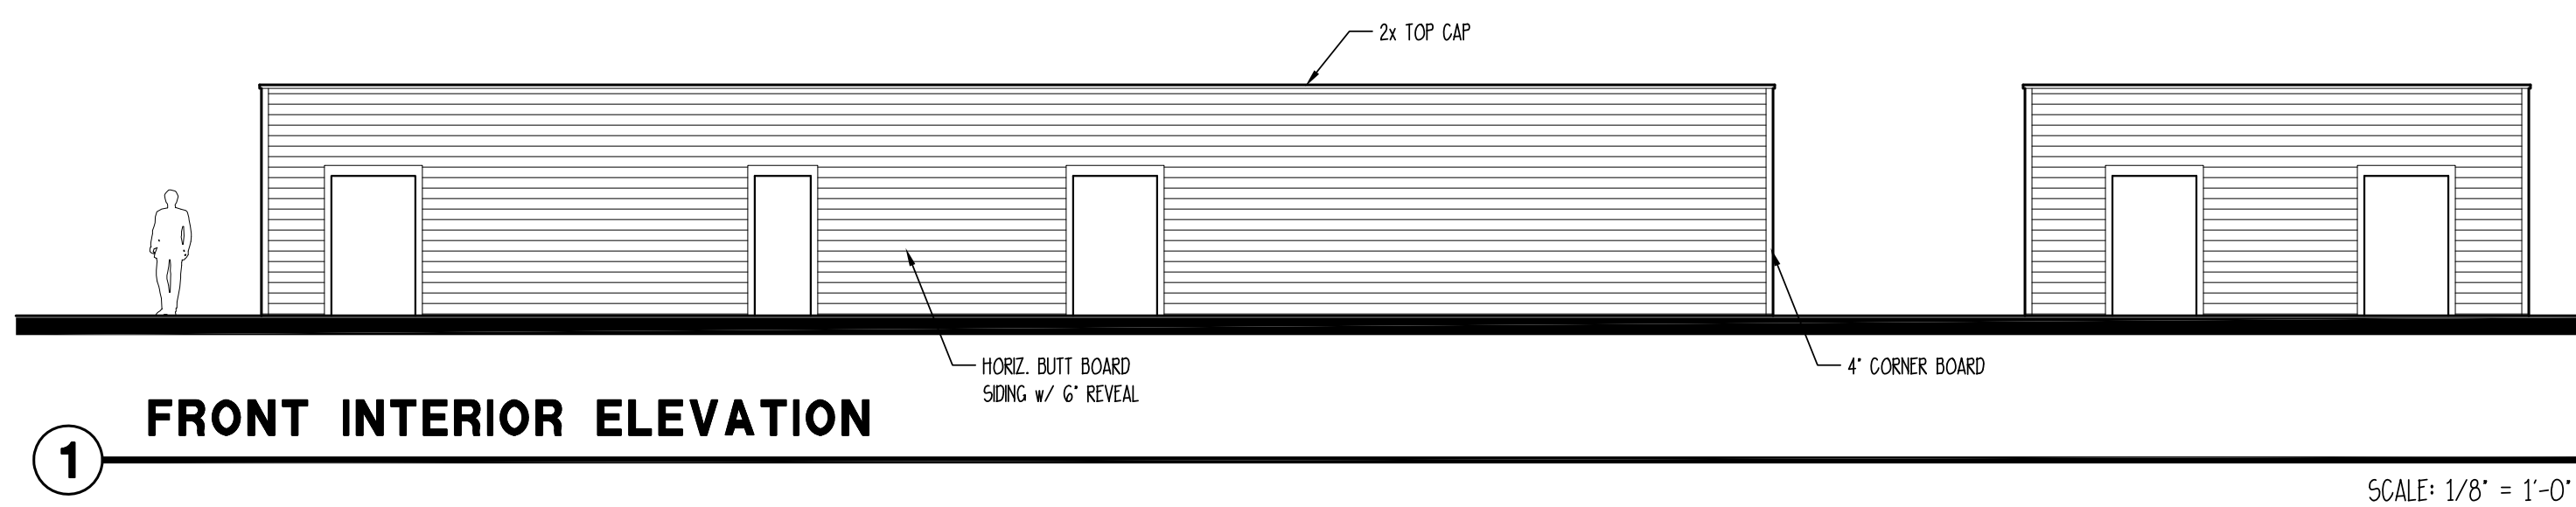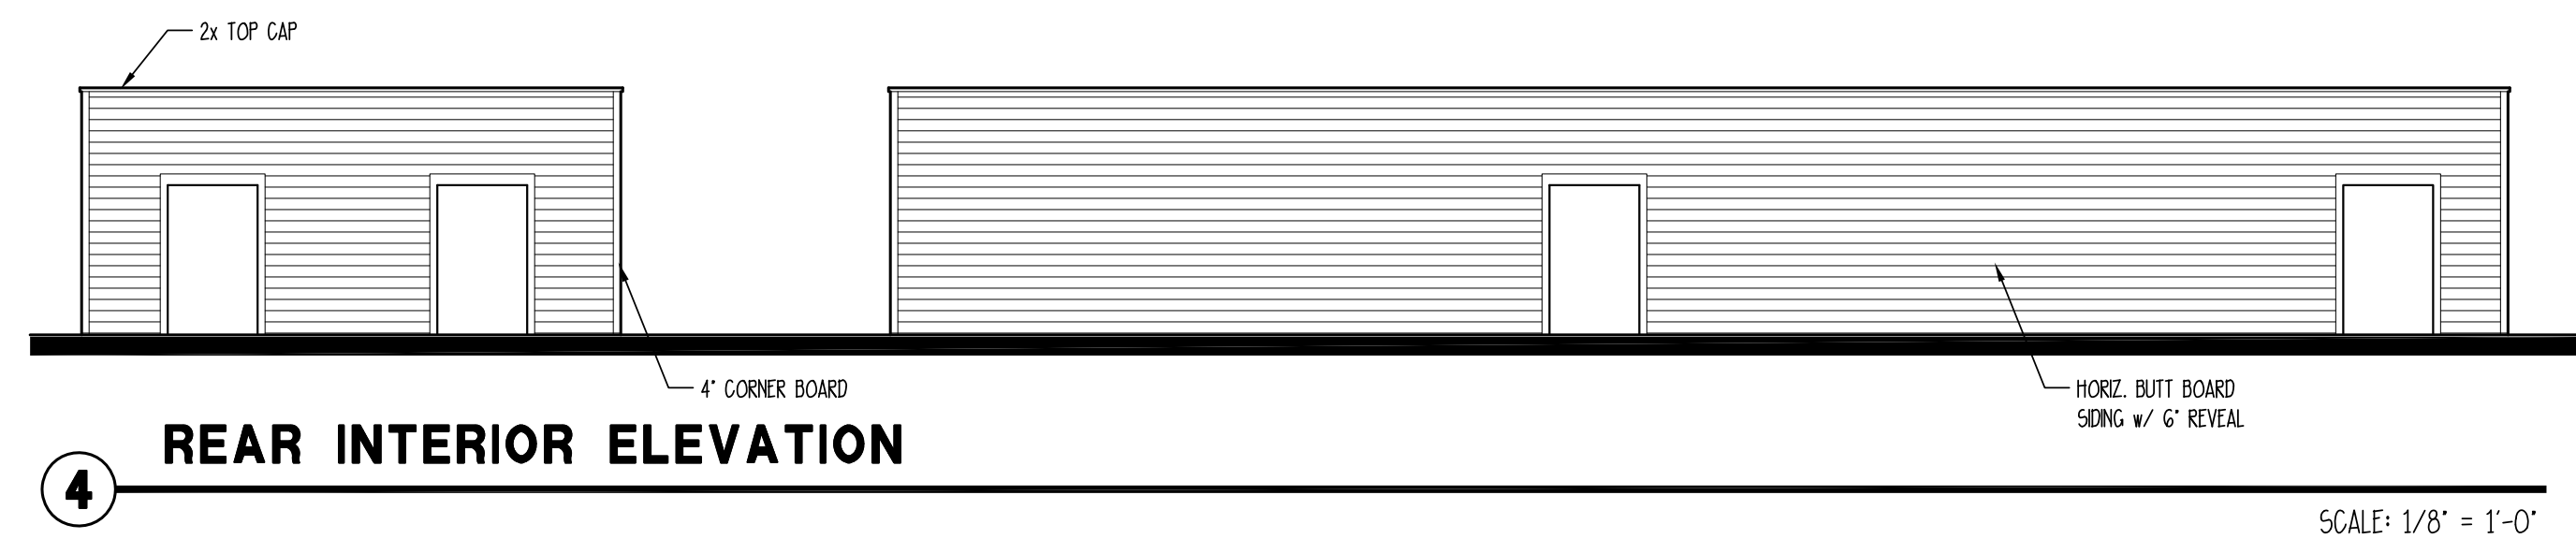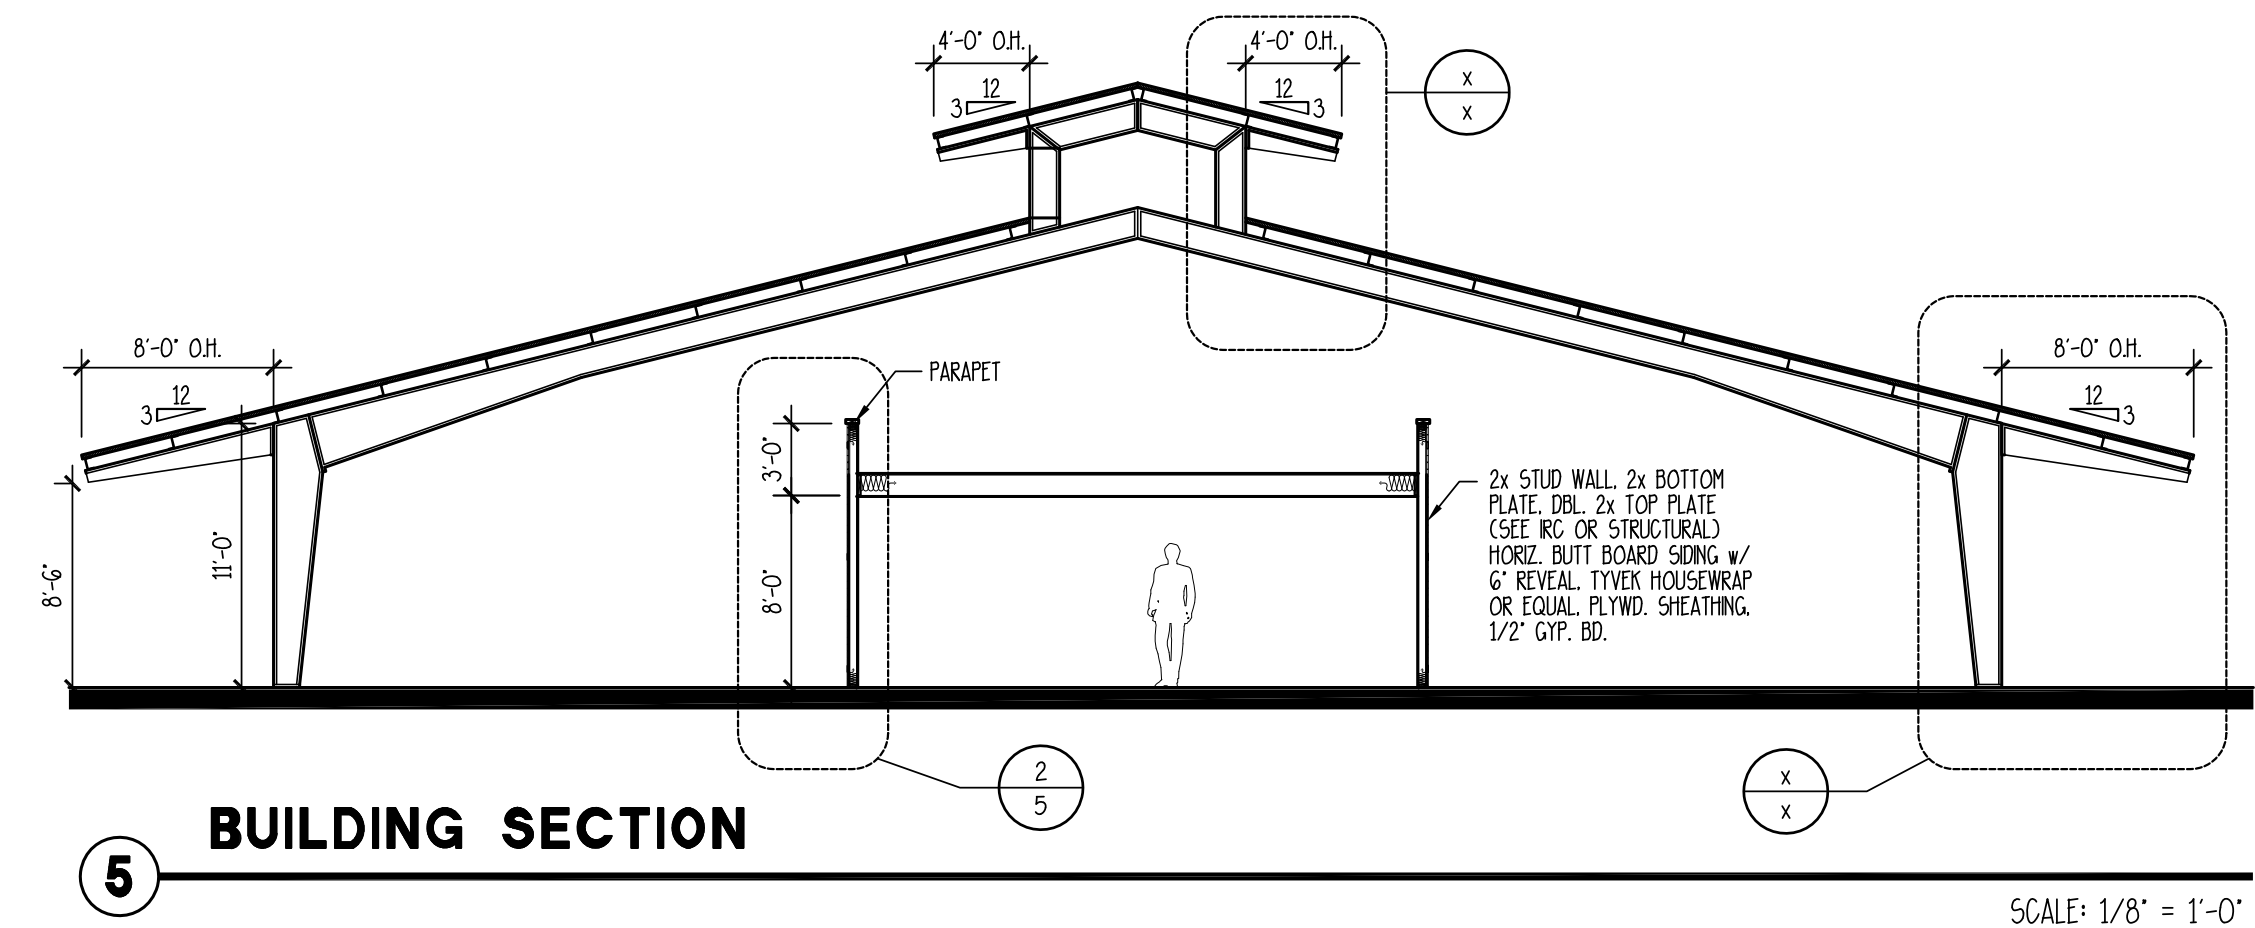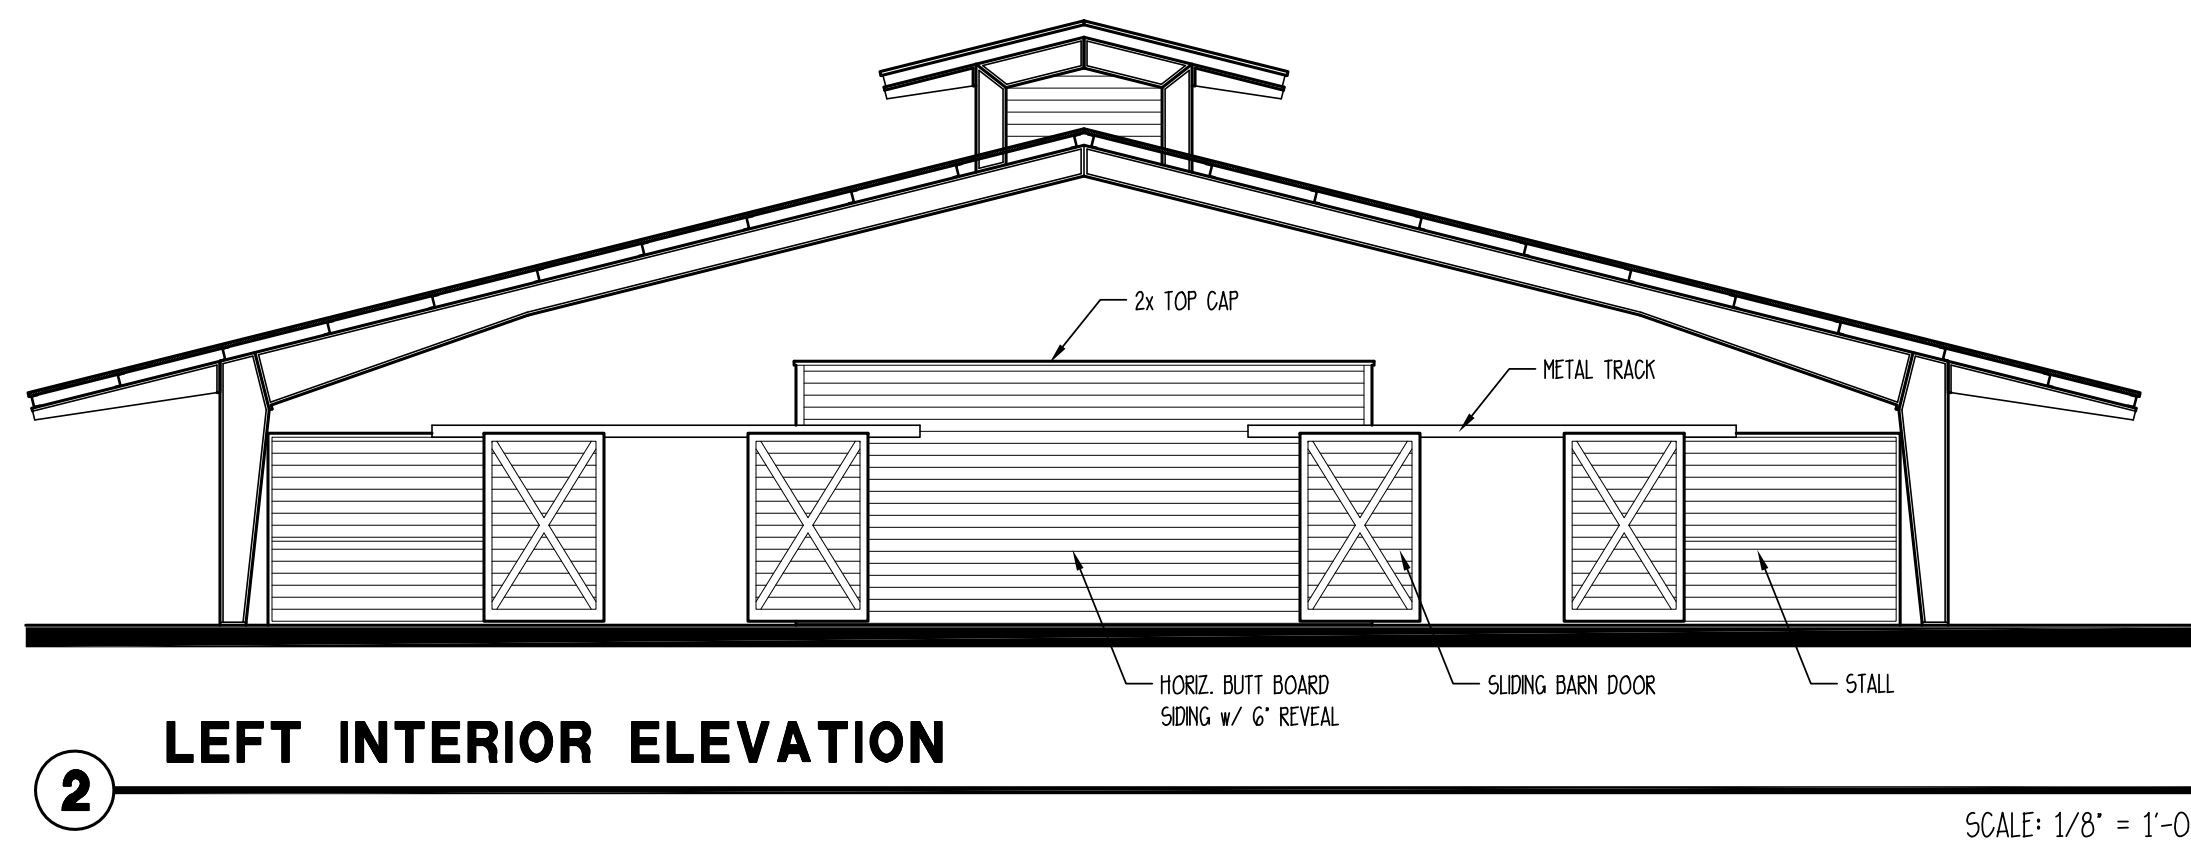

STALL BARN ELECTRICAL LAYOUT

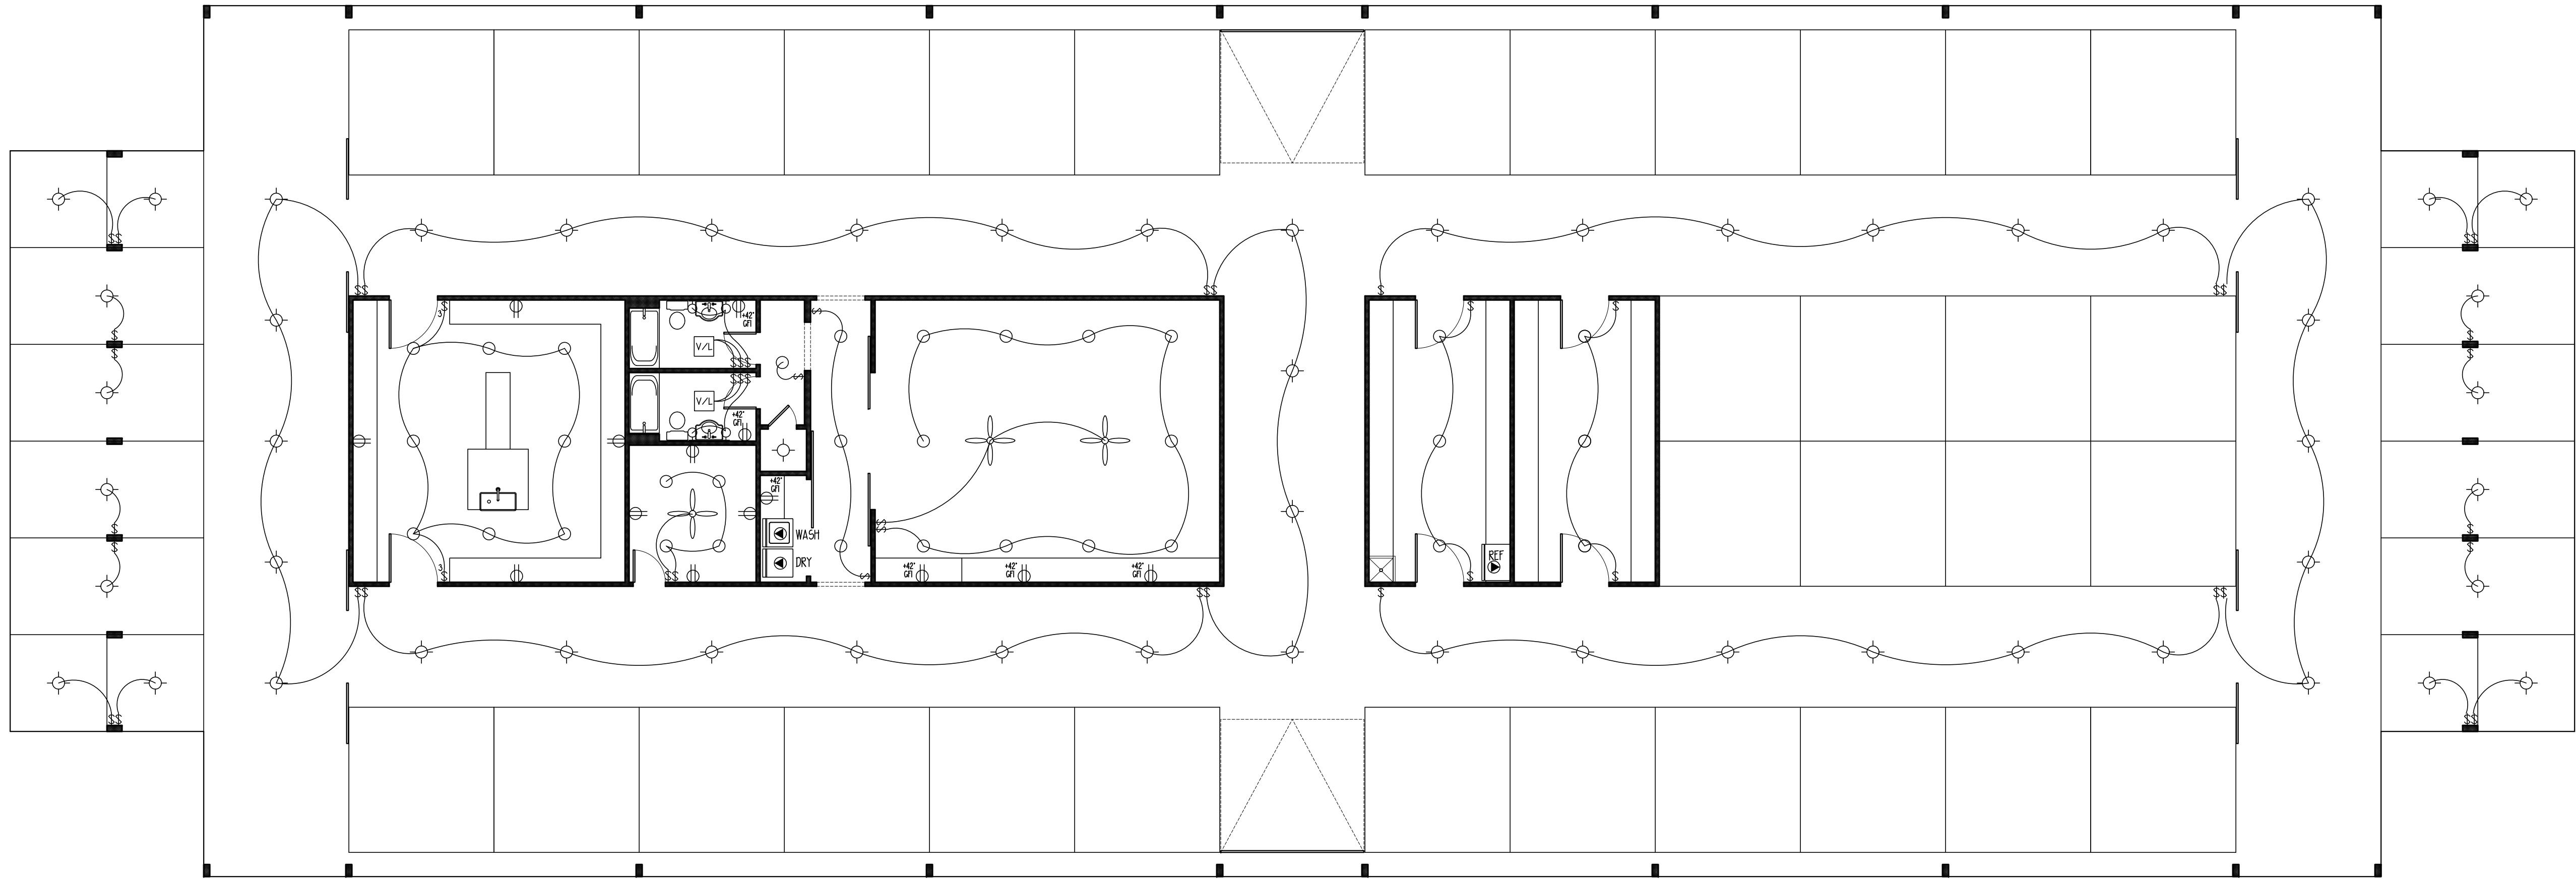

SCALE: 1/8" = 1'-0"

Copyright 2017 by Allison Ramsey Architects, Inc. All rights reserved.

DATE:	6/28/2017
JOB NO.	17201
OWN. BY:	RWH
DWG. NAME:	17201.DWG

THIS PLAN HAS BEEN PREPARED TO MEET THE PROFESSIONAL STANDARDS AND PRACTICES OF THE ARCHITECT. IT IS THE RESPONSIBILITY OF THE ARCHITECT TO PROVIDE THE FOLLOWING: TO THE BEST OF HIS OR HER KNOWLEDGE AND BELIEF, THE DESIGN AND CONSTRUCTION OF THE PROJECT SHALL BE IN ACCORDANCE WITH ALL APPLICABLE CODES, ORDINANCES, AND REGULATIONS. THE ARCHITECT DOES NOT WARRANT OR GUARANTEE THE ACCURACY OF THE INFORMATION PROVIDED HEREON. THE ARCHITECT SHALL NOT BE RESPONSIBLE FOR ANY ERRORS OR OMISSIONS IN THIS PLAN. THE ARCHITECT SHALL NOT BE RESPONSIBLE FOR ANY CONSTRUCTION DEFECTS OR DAMAGE TO THE PROJECT OR TO ANY PERSONS OR PROPERTY. THE ARCHITECT SHALL NOT BE RESPONSIBLE FOR ANY DELAYS OR INTERRUPTIONS IN THE WORK. THE ARCHITECT SHALL NOT BE RESPONSIBLE FOR ANY COSTS OR EXPENSES INCURRED BY THE OWNER OR ANY OTHER PARTY. THE ARCHITECT SHALL NOT BE RESPONSIBLE FOR ANY INJURY OR DAMAGE TO ANY PERSONS OR PROPERTY. THE ARCHITECT SHALL NOT BE RESPONSIBLE FOR ANY OTHER MATTER NOT EXPRESSLY PROVIDED FOR IN THIS PLAN.

ALLISON RAMSEY
Architects, Inc.

creating sustainable timeless design

1003 Charles St.
Beaufort SC 29902
(843) 986-0359
www.allisonramseyarchitect.com

SANCTUARY
STABLES

The diagram illustrates a genus-3 surface, which is a surface with three holes. The boundary of the surface is represented by three horizontal wavy lines. Each line has eight points marked with a circle containing the Greek letter ϕ . The top line has points at the left and right ends, and six points in between. The middle line has points at the left and right ends, and six points in between. The bottom line has points at the left and right ends, and six points in between. The lines are connected at the left and right ends by vertical curves, forming the boundary of the surface.

The diagram illustrates a domain Ω in the plane, bounded by three horizontal wavy lines. The top and bottom boundaries are marked with points labeled ϕ , and the middle boundary is marked with points labeled ψ . The domain is shaded gray.

DATE:	6/28/2017
JOB NO.	17201
DRAWN BY:	RWM
DWG. NAME:	17201.DWG

DATE:	6/28/2017
JOB NO.	17201
DRAWN BY:	RWM
DWG. NAME:	17201.DWG

ALLISON RAMSEY
Architects Inc. creating sustainable timeless design
1003 Charles St.
Beaufort SC, 29902
(843) 984-0559
www.allisonramseyarchitect.com

SANCTUARY STABLES

[illegible]