


Bill Thompson
32'x56'x9' Stud wall Frame Building

Building Colors:
Siding: Rustic Red
Trim: Tan
Roof: Tan
Wainscoating: N/A
Doors: White
Misc. Details: Single bubble ins. on roof, House wrap on sides,
Gutters and downs.

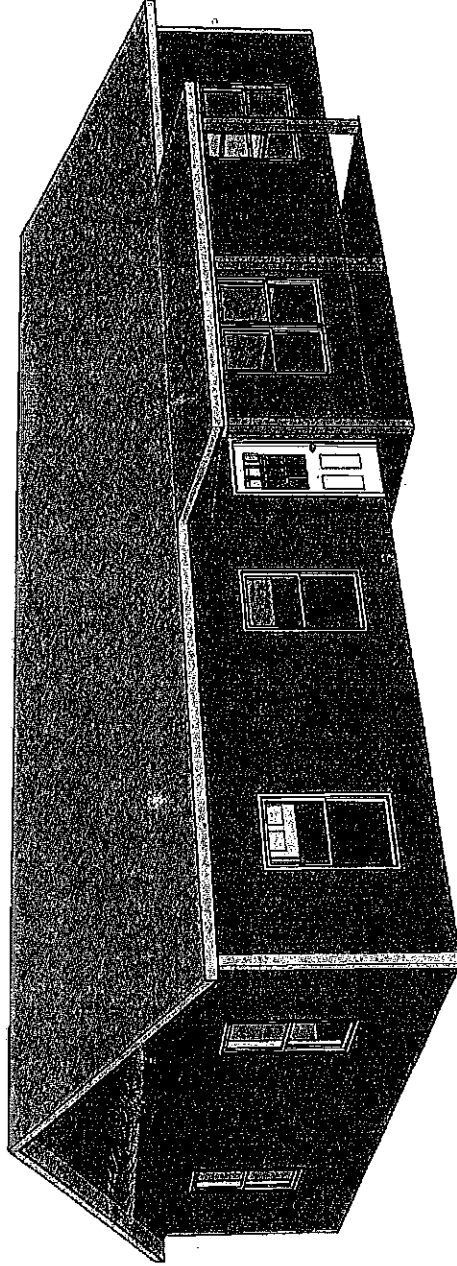

Cover sheet

No scale




Yutzy Construction LLC
24917 N HWY 169
785-448-2191
[www.yutzyconstruction](http://www.yutzyconstruction.com)

Customer:

Bill Thompson
1981 Oregon Rd
Princeton, Ks


1/4"=1'scale

Foundation PLAN

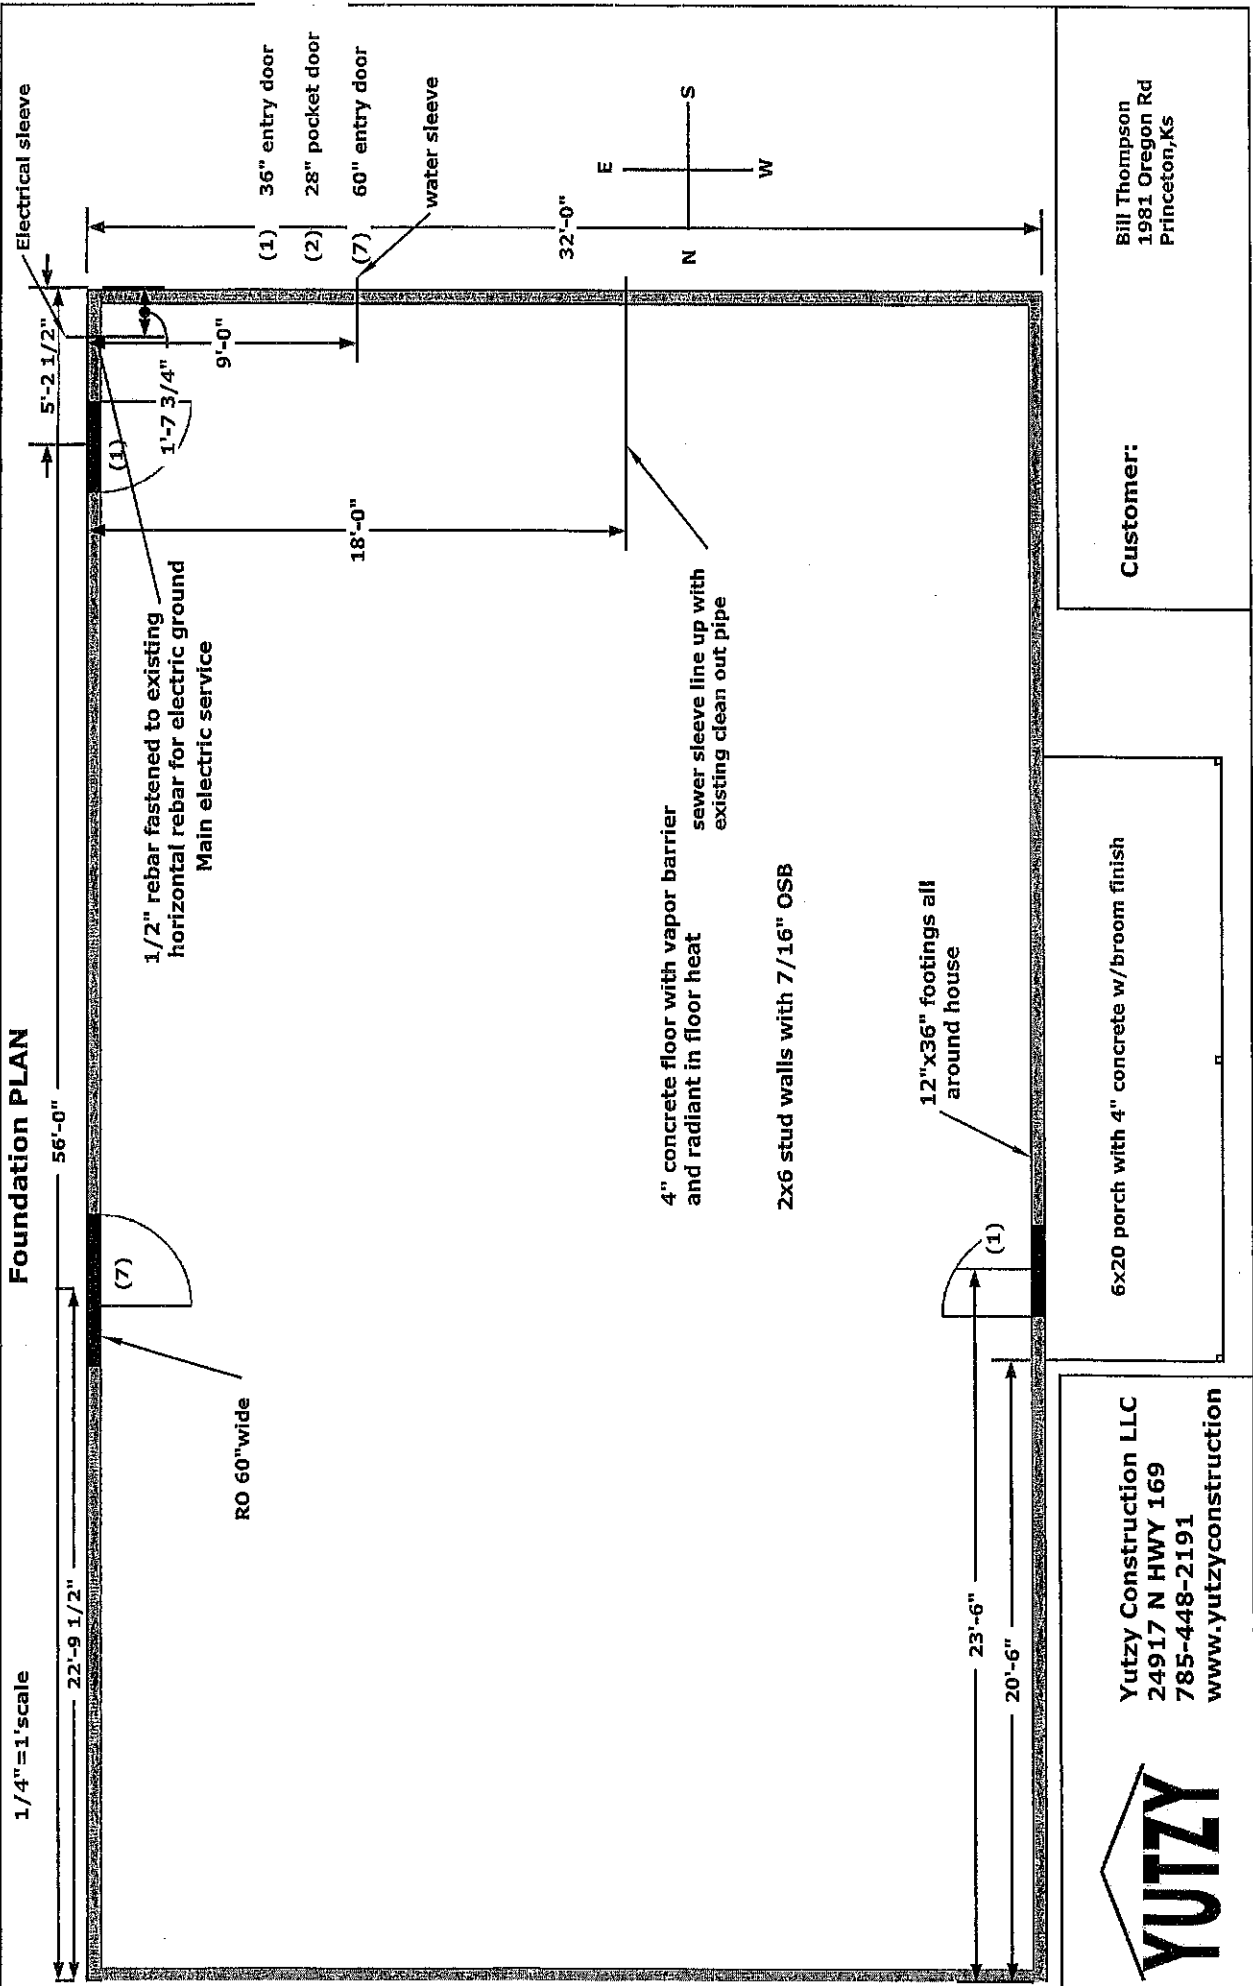

Plumbing Plan

1/4"=1'scale

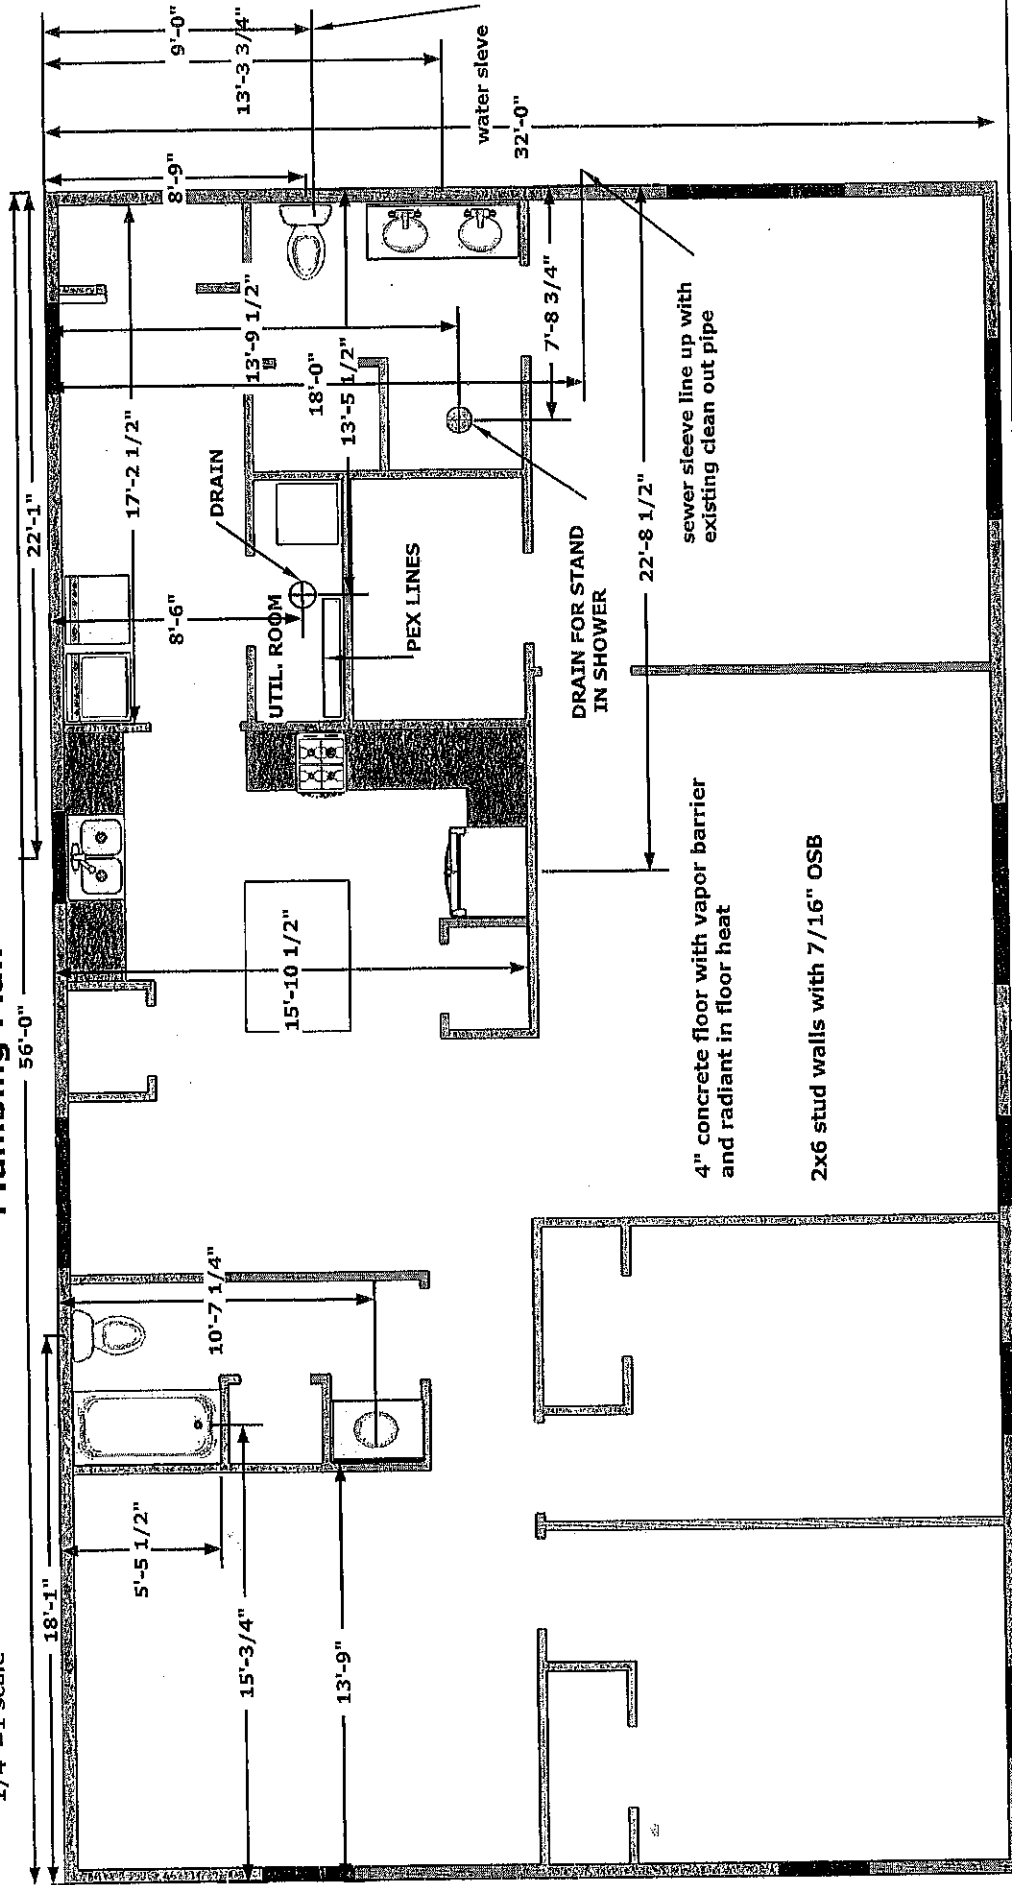

Customer:

Yutzy Construction LLC
24917 N HWY 169
785-448-2191
www.yutzyconstruction


Bill Thompson
1981 Oregon Rd
Princeton, KS

YUTZY

[Handwritten signature]

Foundation Plan with Radiant heat

(Not to Scale)

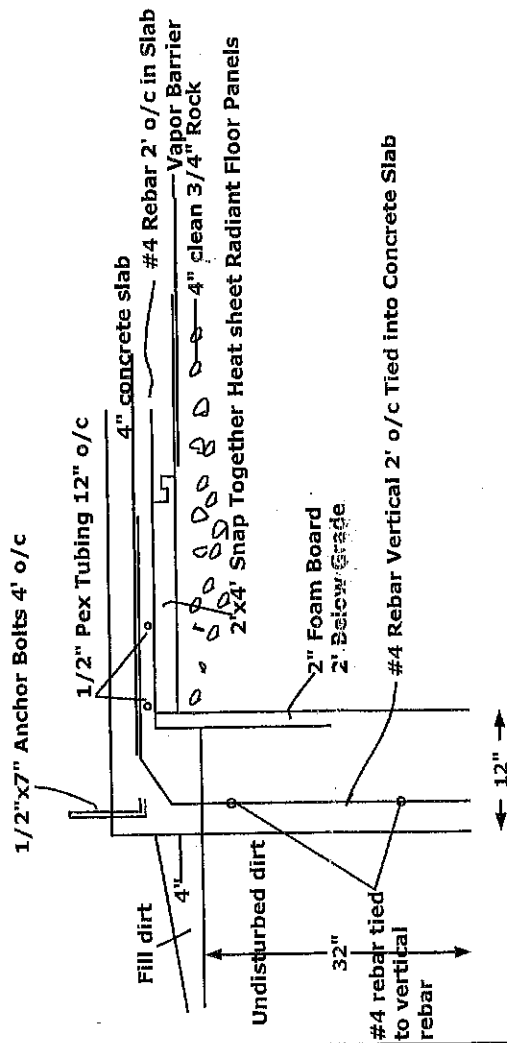


YUTZY
 Yutzy Construction LLC
 20503 NW 1600TH RD
 Garnett KS 66032
 785-248-1397
 www.yutzyconstruction

Customer:

Bill Thompson
 1981 Oregon Rd
 Princeton, KS

Typical header and top plate design (Not to Scale)

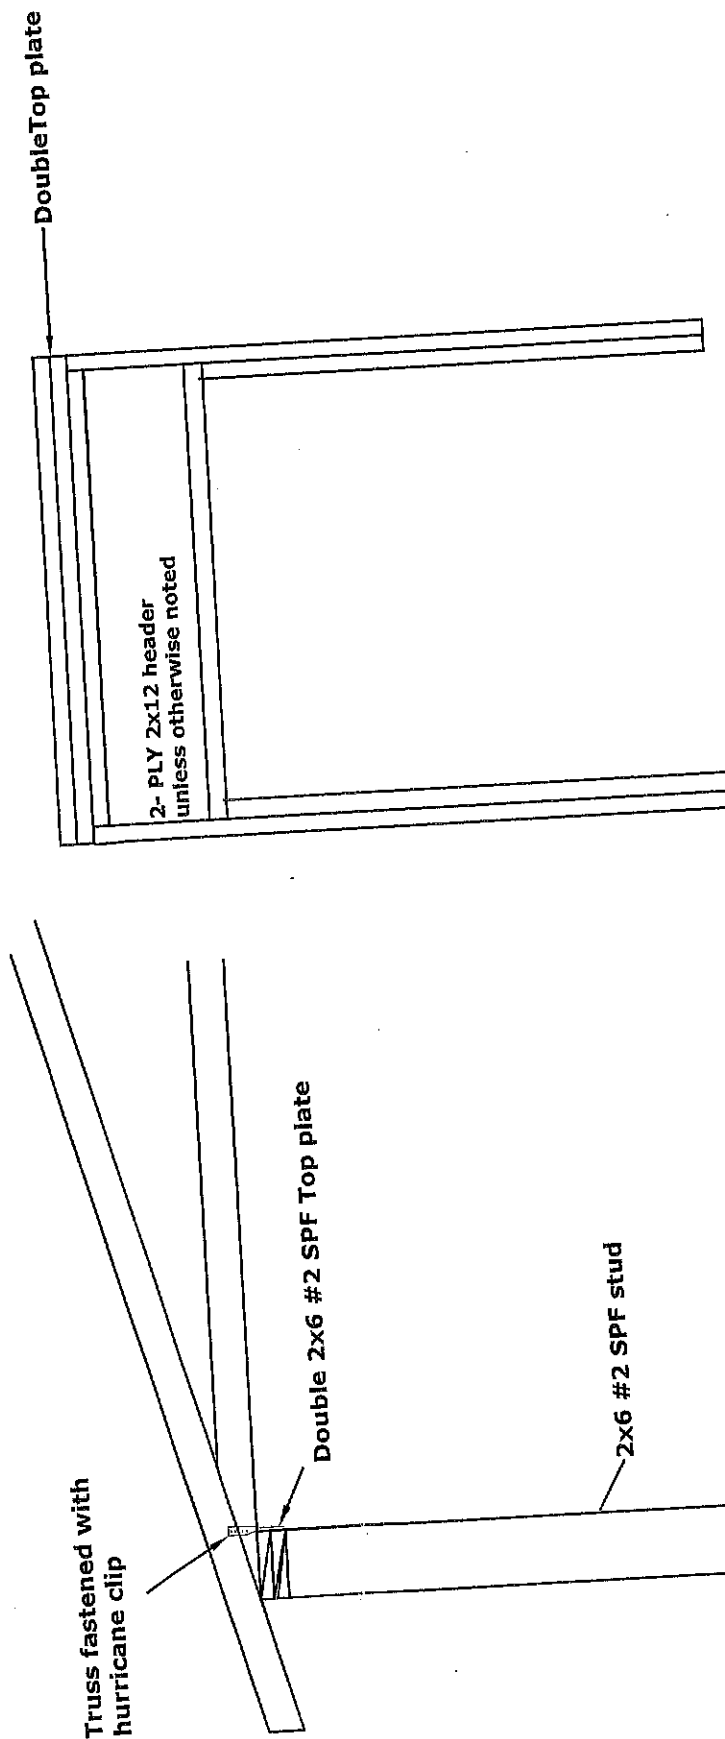


Bill Thompson
1981 Oregon Rd
Princeton, Ks

Customer:

Yutzy Construction LLC
20503 NW 1600TH RD
Garnett KS 66032
785-248-1397
www.yutzyconstruction

YUTZY

Typical Stud Wall Section (Not to Scale)

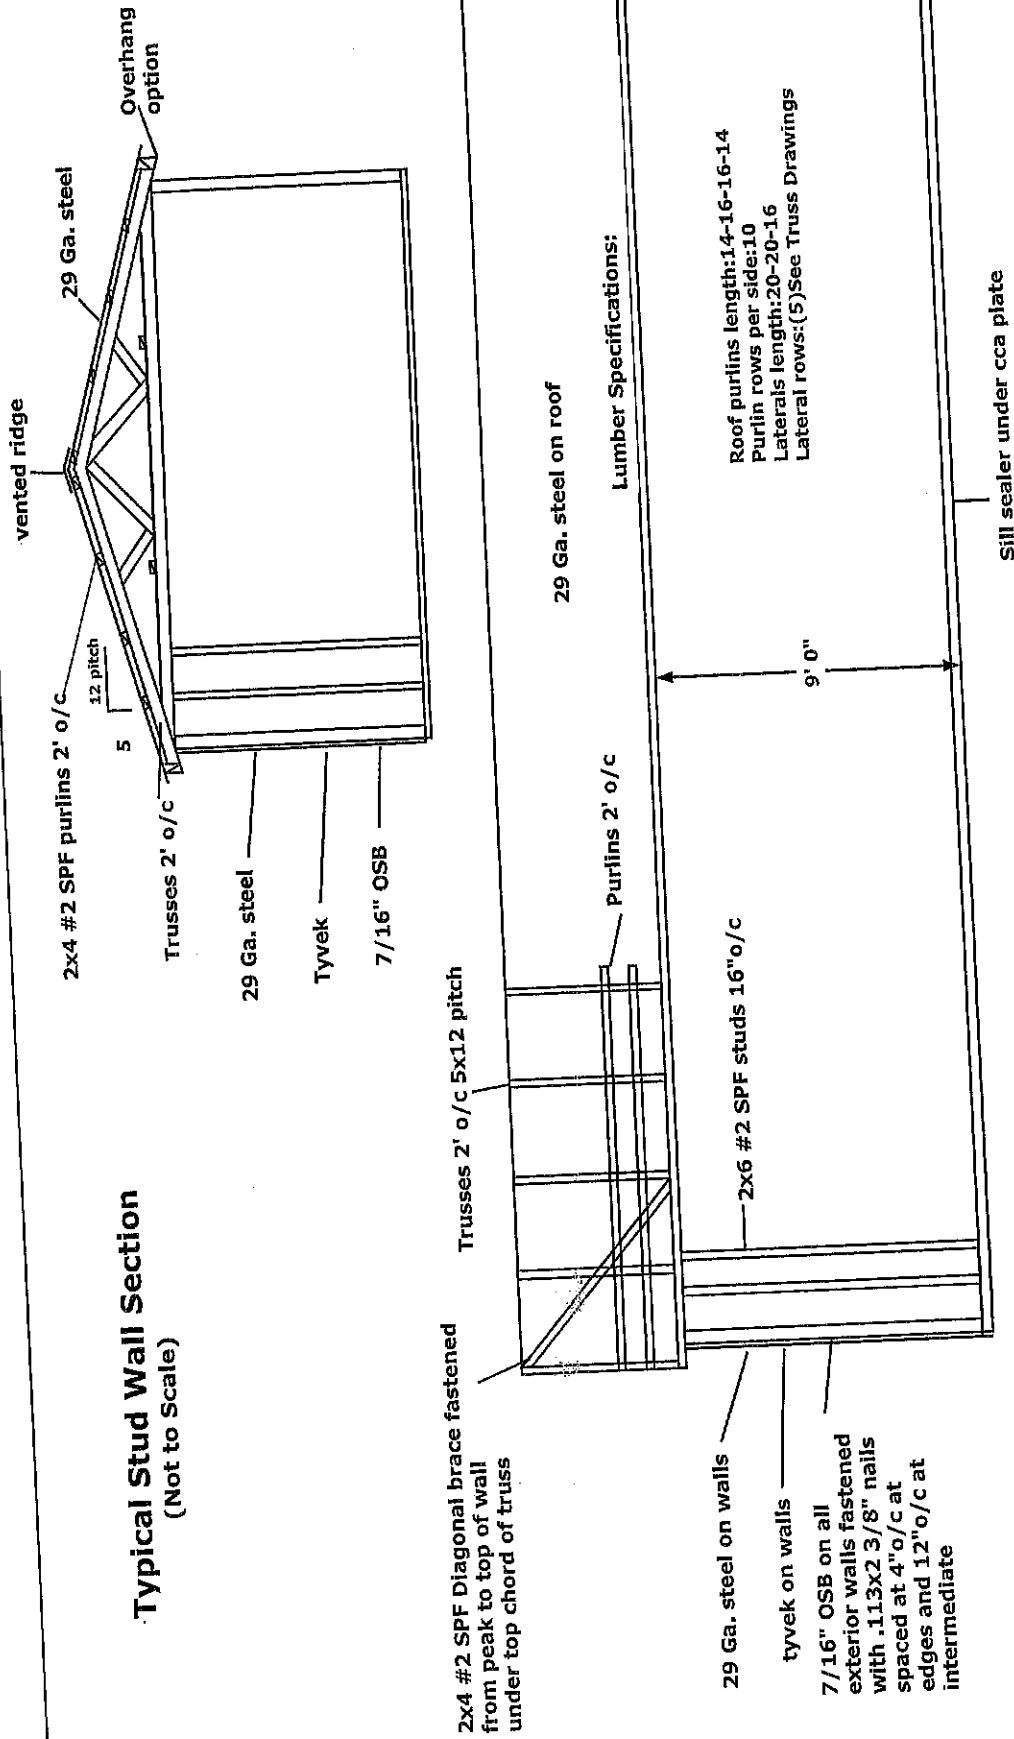

Customer:

Bill Thompson
1981 Oregon Rd
Princeton, Ks


Yutzy Construction LLC
20503 NW 1600TH RD
Garnett KS 66032
785-248-1397
www.yutzyconstruction

YUTZY

Typical Lean-to Section

(not to scale)

() = Quantity of ledgerloks into post, 1/2 of the amount on each end of truss support is required. A 3-ply truss support is required notch the 3rd ply into 1-side of the post and use 5" Ledgerlok to secure the side with the doubled up truss support to the post

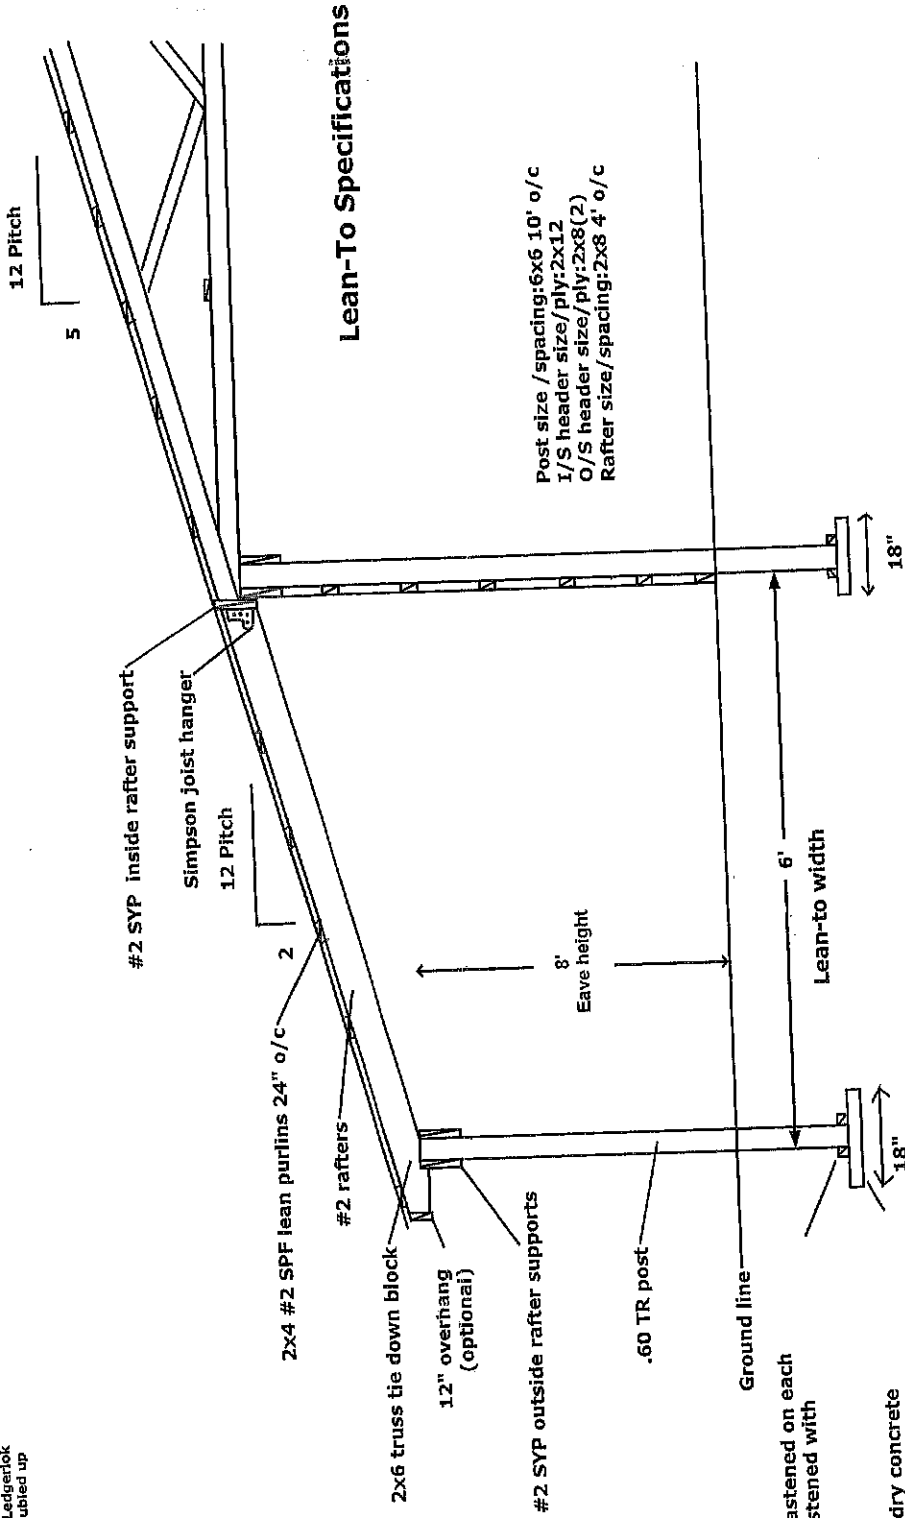

Lean-To Specifications





Bill Thompson
1981 Oregon Rd
Princeton, Ks

Customer:

Yutzy Construction LLC
20503 NW 1600TH RD
Garnett KS 66032
785-248-1397
www.yutzyconstruction.com

YUTZY

Elevations

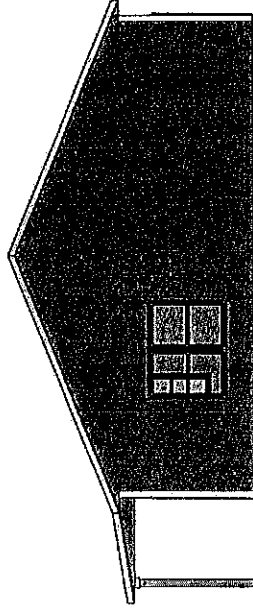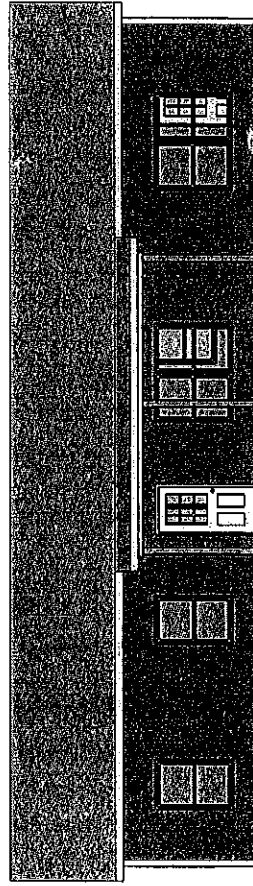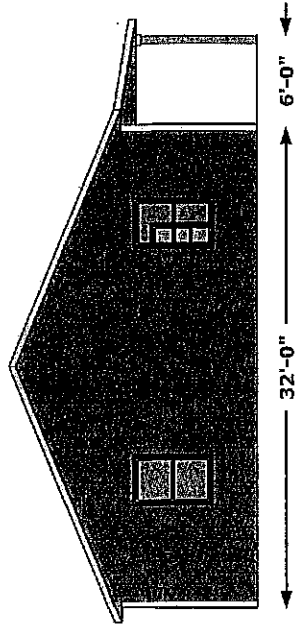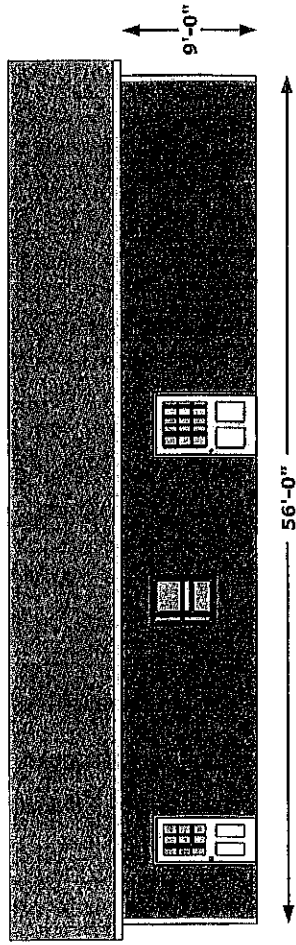

1/8" TO SCALE

YUTZY
Yutzy Construction LLC
24917 N HWY 169
785-448-2191
www.yutzyconstruction

Customer:

Bill Thompson
1981 Oregon Rd
Princeton, Ks