


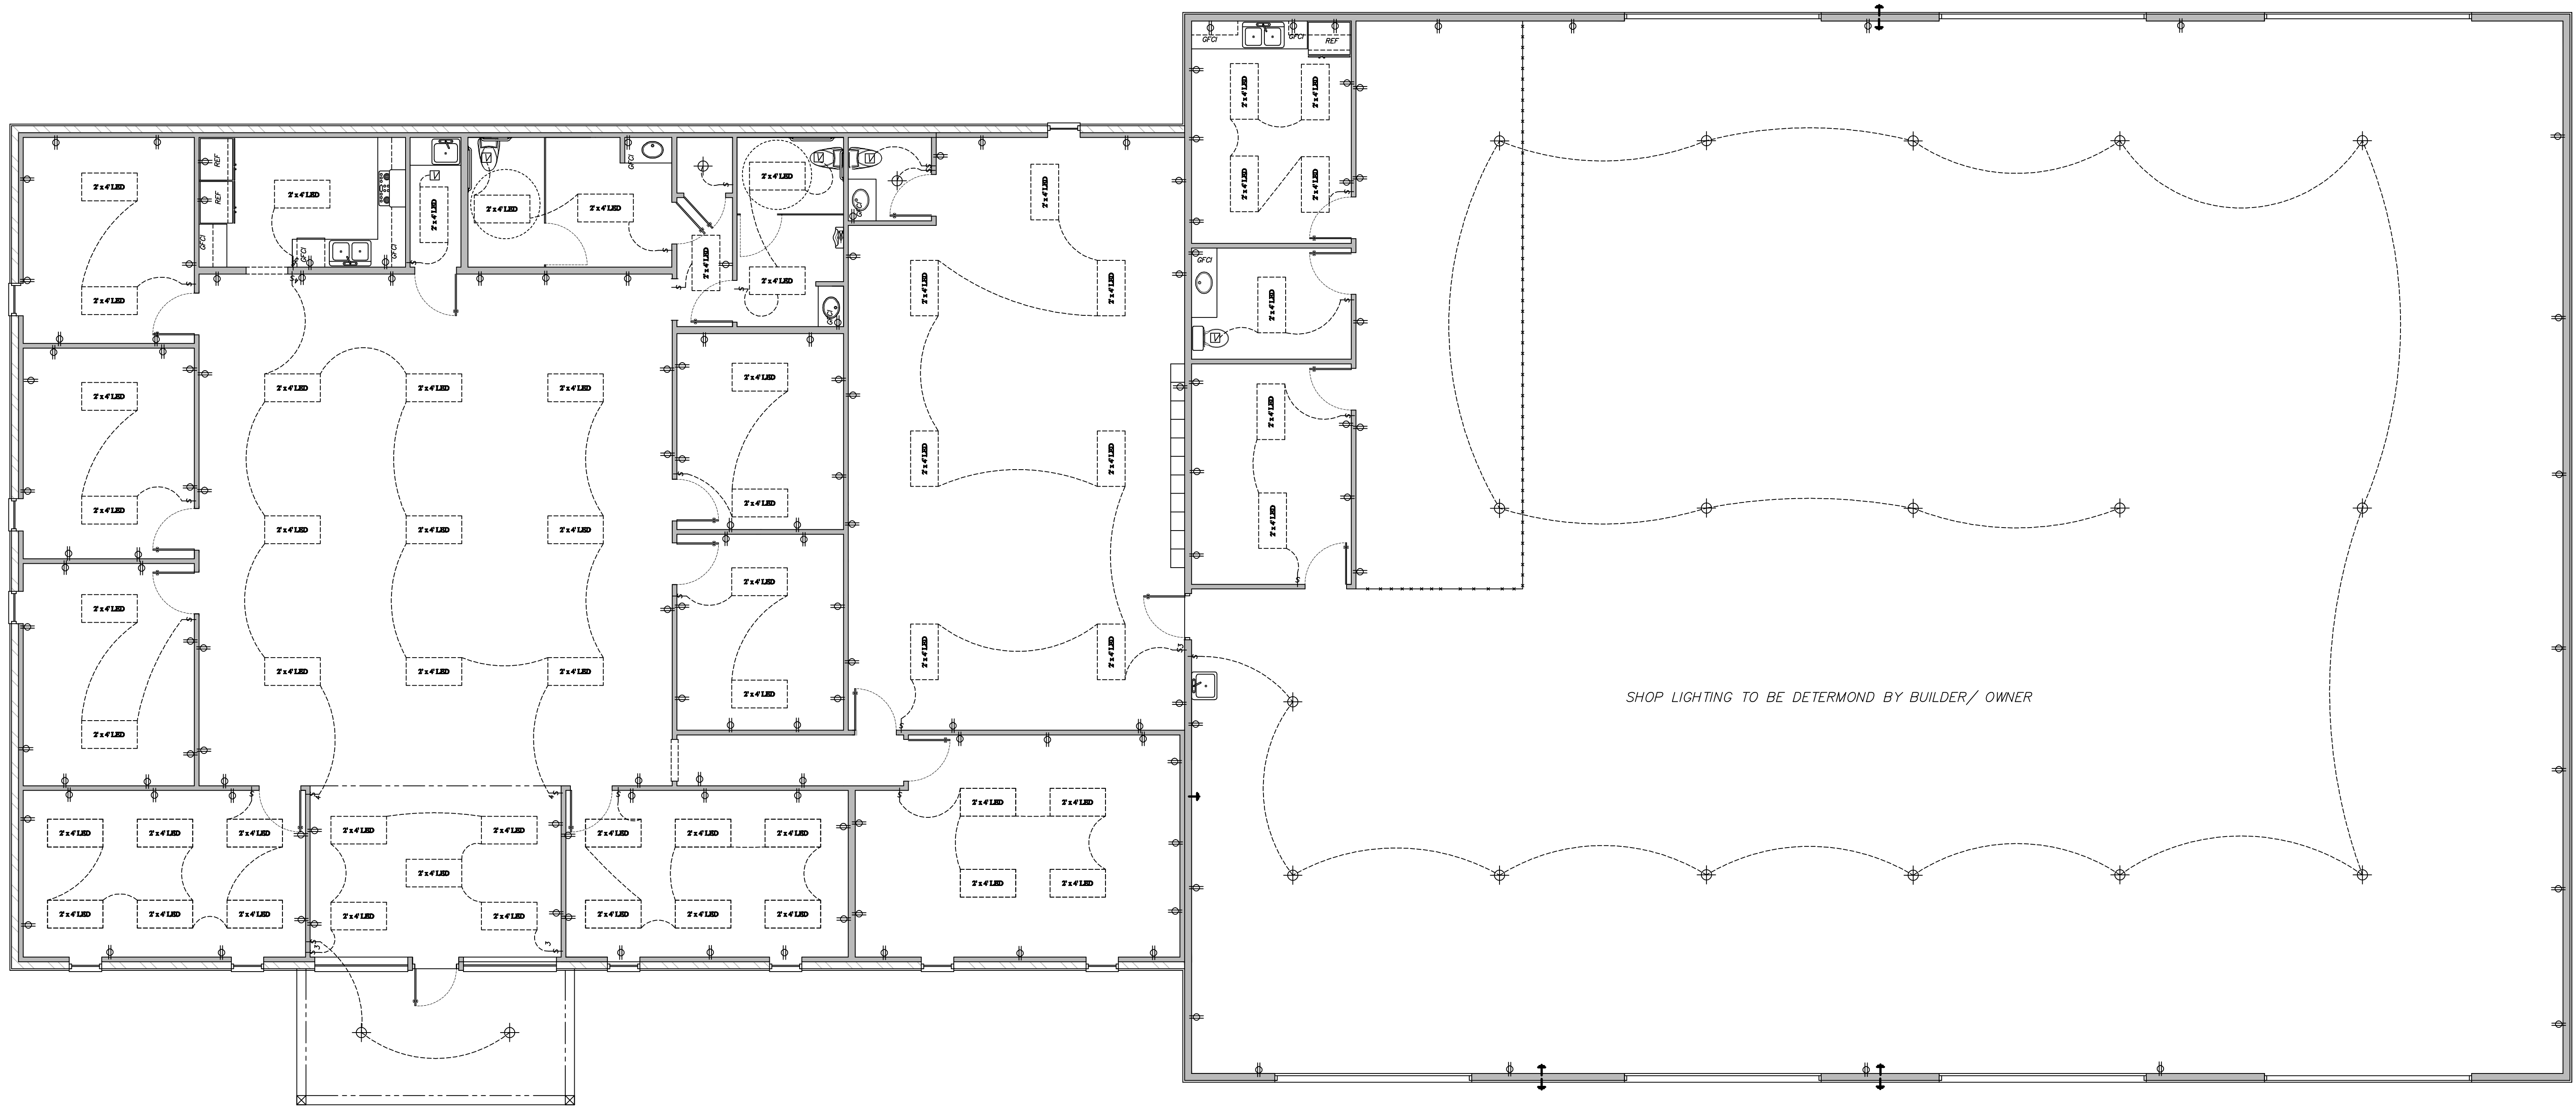

ELECTRICAL LEGEND	
	FAN
	FAN WITH LIGHT
	CHANDELIER
	LIGHT FIXTURE
	MOTION LIGHT
	RECESSED LIGHT
	EYEBALL FIXTURE
	LIGHT SWITCH
	3-WAY LIGHT SWITCH
	SMOKE DETECTOR
	LIGHT
	VENT
	HEATER
	PLUG LOCATED BY OWNER
	110 PLUG
	220 PLUG
	GROUND FAULT PLUG
	110 FOUR PLEX
	WATER PROOF PLUG
	CABLE FOR TELEVISION
	PHONE JACK
	BAR LIGHT
	COAX CABLE
	ROPE LIGHT
	UNDER/IN CABINET LIGHTING
	2'x4' LED UNIT

ELECTRICAL PLAN
SCALE 3/16" = 1'-0"

PLAN NO. PROVINCIAL C H	SHEET 4 OF 5	DATE: AUG2023	DRAWN BY: Pompa	Daniel W. Pompa Phone(817)565-0037	313 Sweetwater Dr. Weatherford, Texas 79086
				Texas Custom Residential Design LLC	