


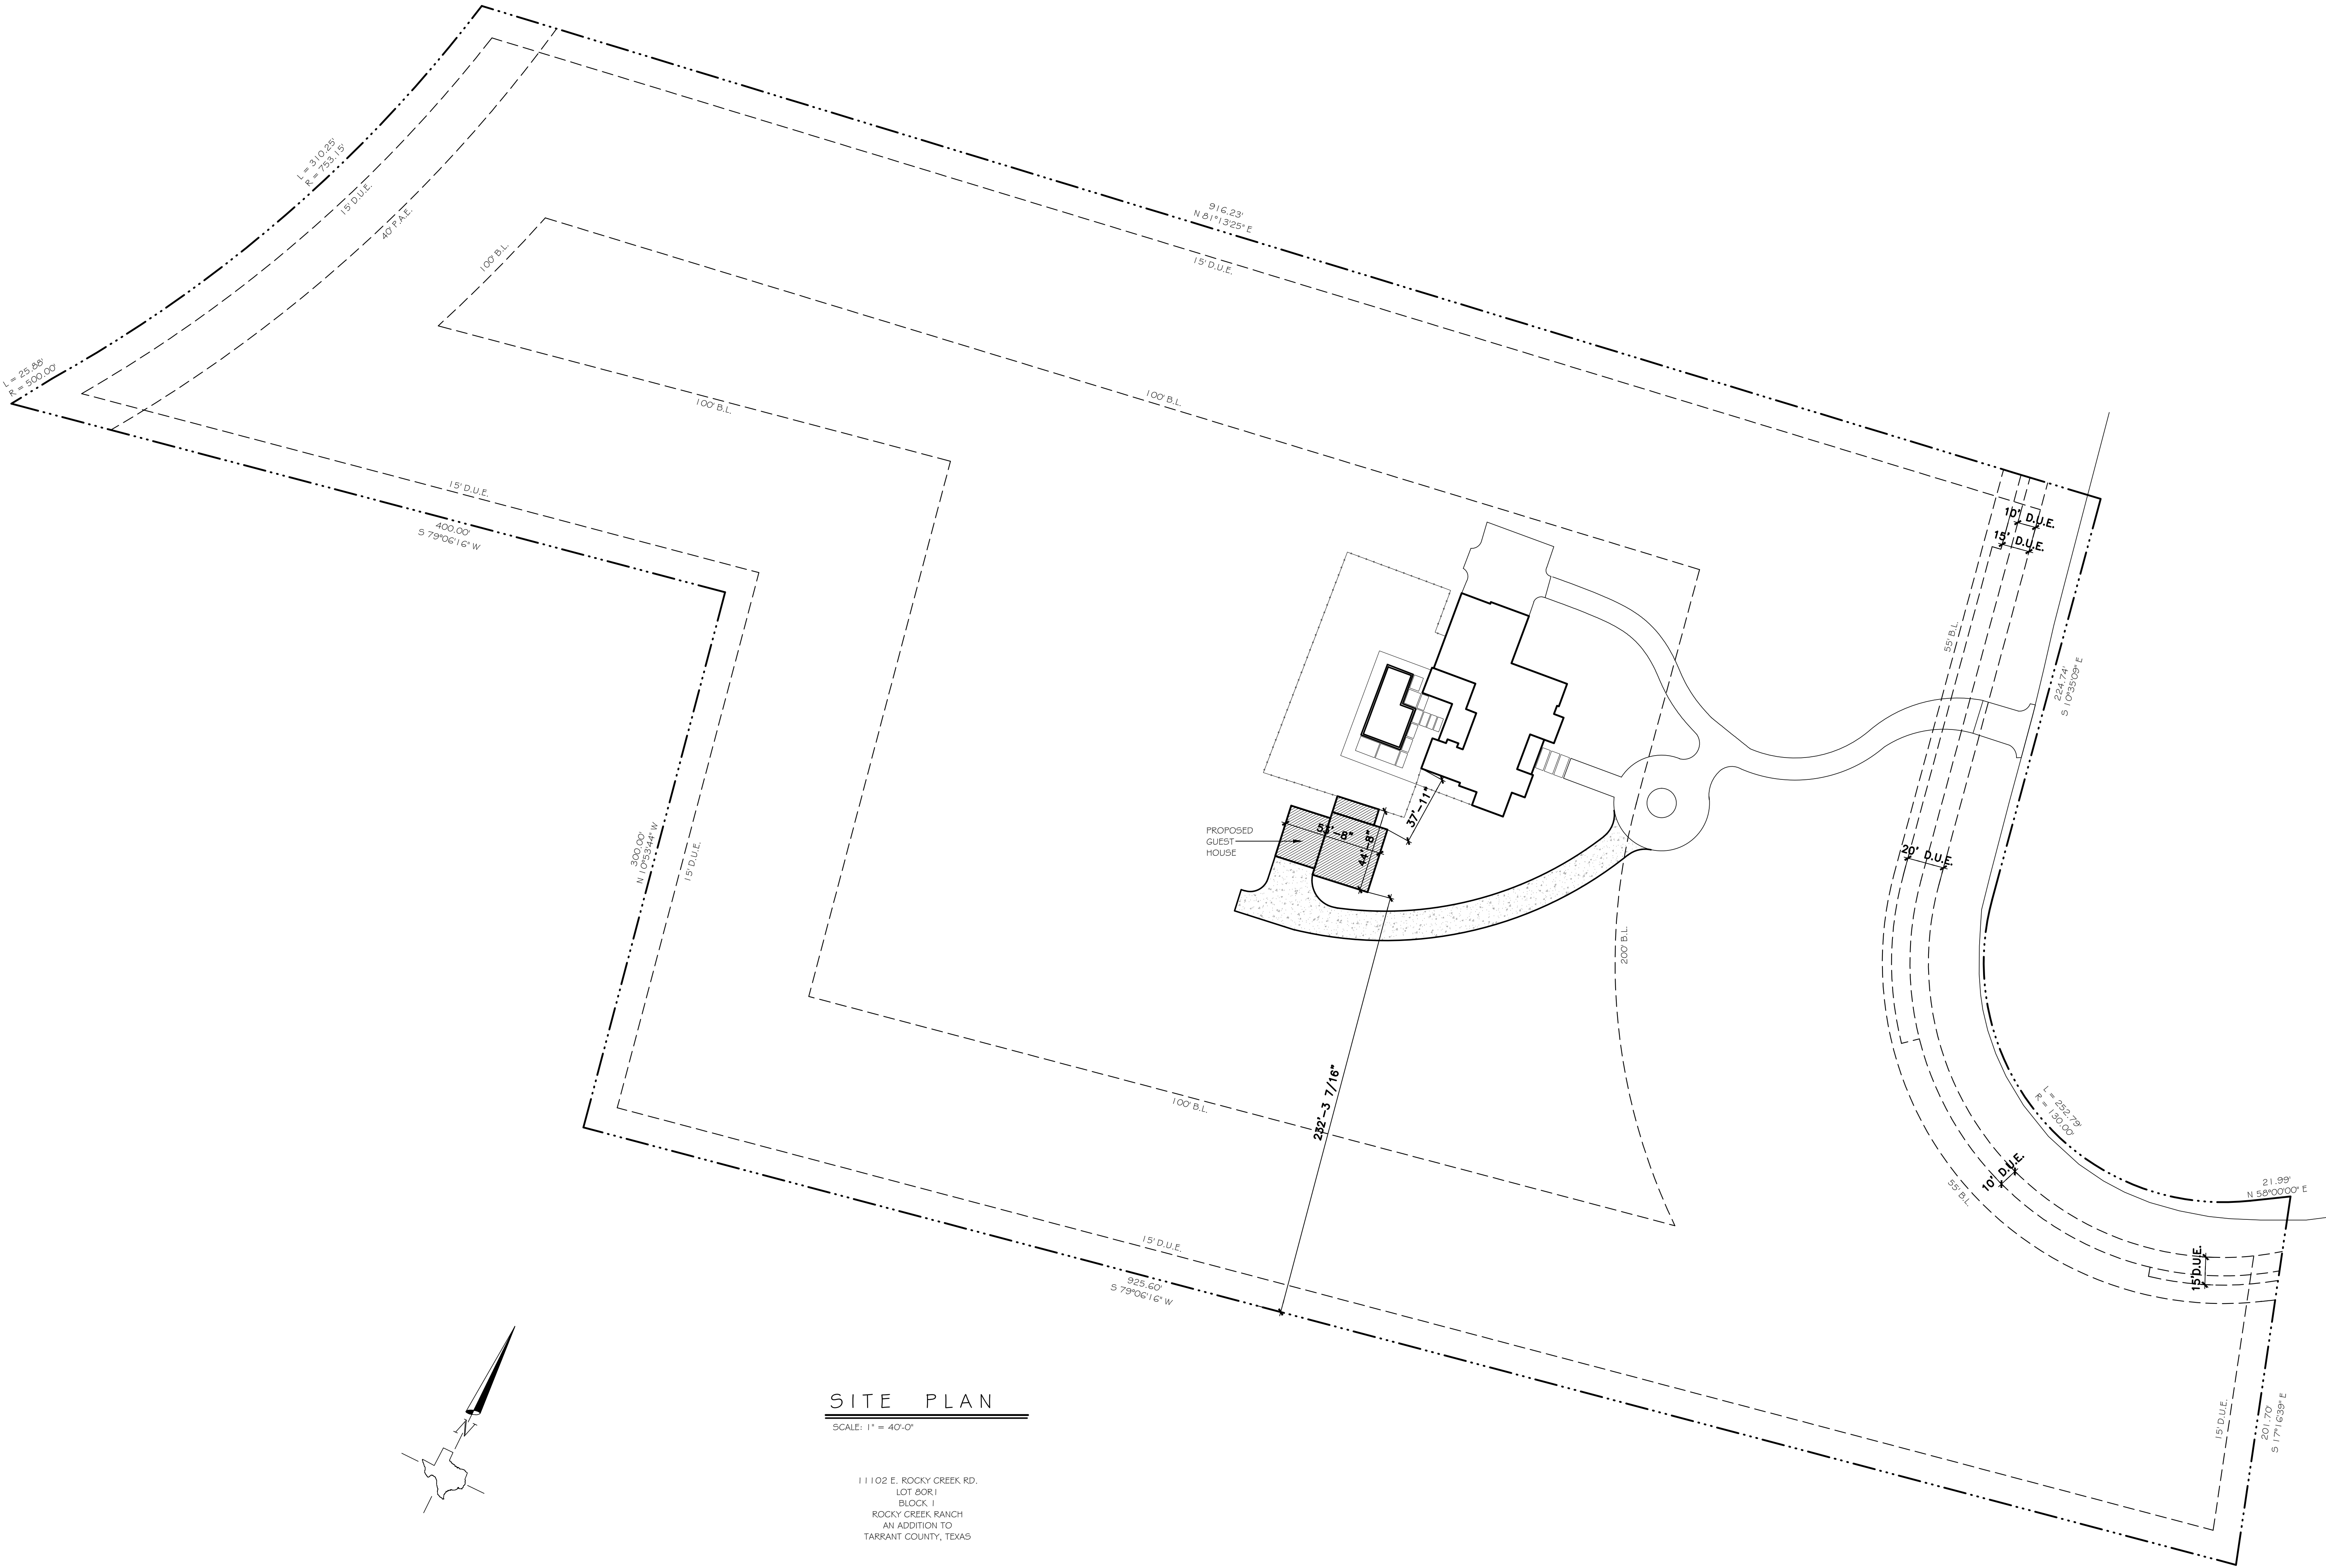

SITE PLAN

SCALE: 1" = 40'-0"

11102 E. ROCKY CREEK RD.
LOT 80R1
BLOCK 1
ROCKY CREEK RANCH
AN ADDITION TO
TARRANT COUNTY, TEXAS

CUSTOM

Drawn By:	Checked By:
CN	CN


THESE PLANS ARE INTENDED TO PROVIDE BASIC CONSTRUCTION INFORMATION, AND ARE FOR ARCHITECTURAL DESIGN ONLY. THESE PLANS MUST BE VERIFIED AND CHECKED BY THE CONTRACTOR/OWNER AND ALL CONTRACTORS OF THIS JOB PRIOR TO CONSTRUCTION. CONTRACTOR/OWNER SHOULD OBTAIN ANY ENGINEERING SERVICES NECESSARY BEFORE BEGINNING CONSTRUCTION OF ANY KIND. ALL FEDERAL, STATE, AND LOCAL CODES AND ORDINANCES TAKE PRECEDENCE OVER ANY PART OF THESE PLANS. DESIGNER WILL NOT ASSUME ANY LIABILITY FOR ANY DAMAGES, DUE TO ERRORS, OMISSIONS, OR CHANGES TO THESE PLANS. THE PURCHASE OF THESE PLANS ENTITLES THE BUYER TO CONSTRUCT THIS HOUSE ONLY ONCE. ANY COPYING, TRACING, OR ALTERING OF THESE PLANS IS NOT PERMITTED. VIOLATORS WILL BE SUBJECT TO PROSECUTION UNDER COPYRIGHT LAWS.

INCLUDED IN THIS SET OF PLANS
SITE PLAN (IF NEEDED)
DIMENSIONED FLOOR PLAN
4 ELEVATIONS
ROOF PLAN
ELECTRICAL PLAN
CLASS C FOUNDATION PLAN



A Custom Residence For:
HUPRICH/KELLEY GUEST HOUSE

Builder:
O

CHAD NORTON
OWNER
(817) 408-5157

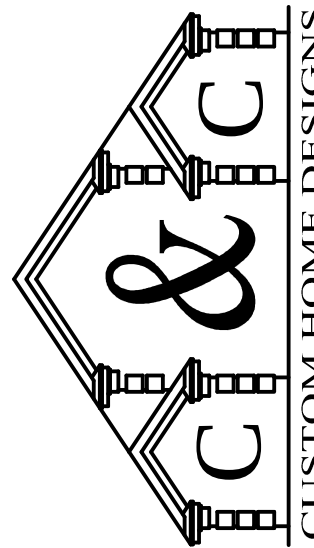

Plan Name:
H/K GUEST HOUSE
Sheet No:
SITE PLAN
Date:
8/31/2022 11:48:28 AM

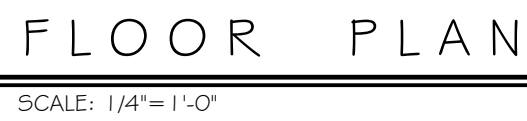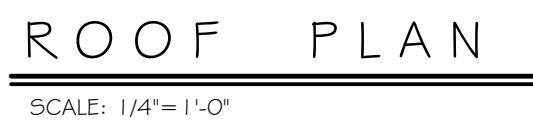


AREAS	SQ.FT.
TOTAL A/C	1118
PATIO	213
GARAGE	640
TOTAL AREA UNDER ROOF	1971
TOTAL SLAB	1971

CUSTOM	
Drawn By: CN	Checked By: CN

THESE PLANS ARE INTENDED TO PROVIDE BASIC CONSTRUCTION INFORMATION, AND ARE FOR ARCHITECTURAL DESIGN ONLY. THESE PLANS MUST BE VERIFIED AND CHECKED BY THE CONTRACTOR/OWNER AND ALL CONTRACTORS OF THIS JOB PRIOR TO CONSTRUCTION. CONTRACTOR/OWNER SHOULD OBTAIN ANY ENGINEERING SERVICES NECESSARY BEFORE BEGINNING CONSTRUCTION OF ANY KIND. ALL FEDERAL, STATE, AND LOCAL CODES AND ORDINANCES TAKE PRECEDENCE OVER ANY PART OF THESE PLANS. DESIGNER WILL NOT ASSUME ANY LIABILITY FOR ANY DAMAGES DUE TO ERRORS, OMISSIONS, OR CHANGES TO THESE PLANS. THE PURCHASE OF THESE PLANS ENTITLES THE BUYER TO CONSTRUCT THIS HOUSE ONLY ONCE. ANY COPYING, TRACING, OR ALTERING OF THESE PLANS IS NOT PERMITTED. VIOLATORS WILL BE SUBJECT TO PROSECUTION UNDER COPYRIGHT LAWS.


A Custom Residence For: HUPRICH/KELLEY GUEST HOUSE Builder: O	INCLUDED IN THIS SET OF PLANS
	SITE PLAN (IF NEEDED) DIMENSIONED FLOOR PLAN 4 ELEVATIONS ROOF PLAN ELECTRICAL PLAN CLASS C FOUNDATION PLAN

CHAD NORTON
OWNER
(817) 408-5157

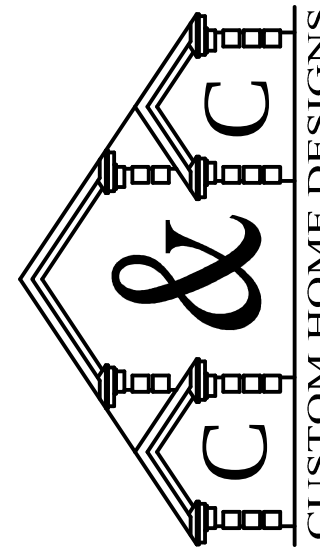


C & C Custom Home Designs

Plan Name:	H/K GUEST HOUSE
Sheet No:	1 of 3
Date:	8/31/2022 11:45:52 AM

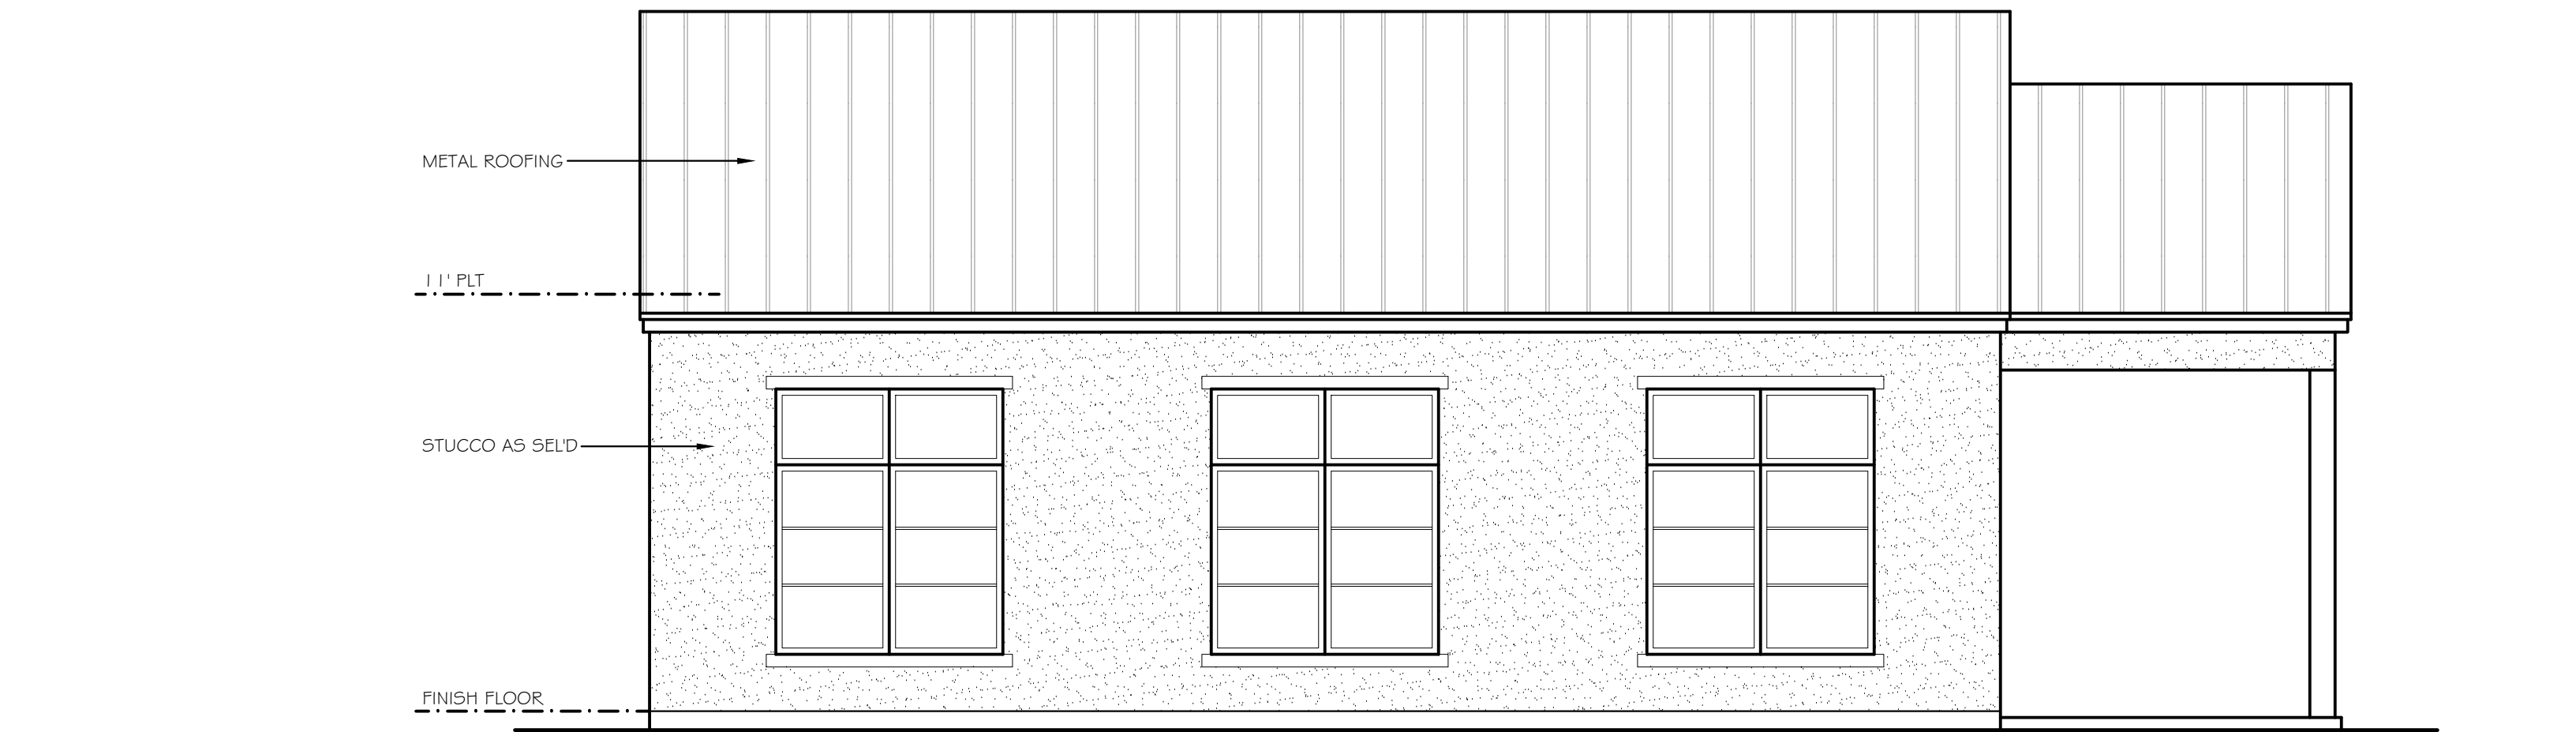


FRONT ELEVATION

SCALE: 1/4"= 1'-0"

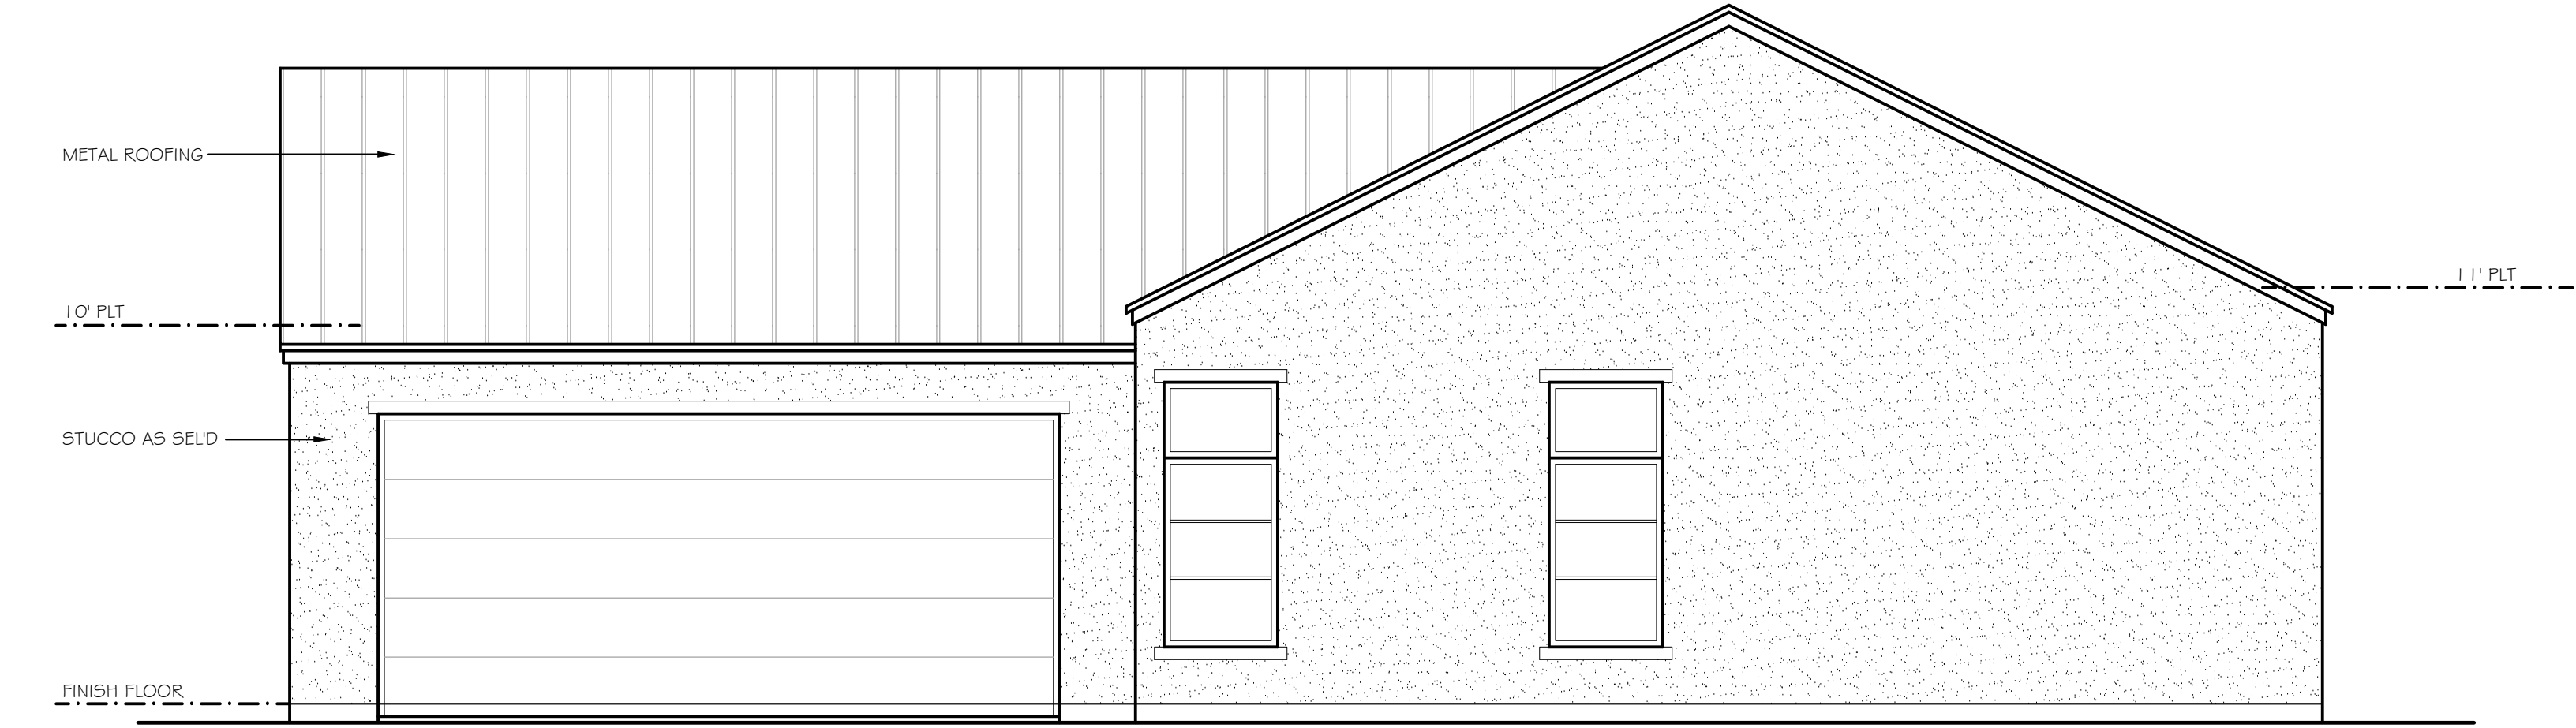


LEFT ELEVATION

SCALE: 1/4"= 1'-0"

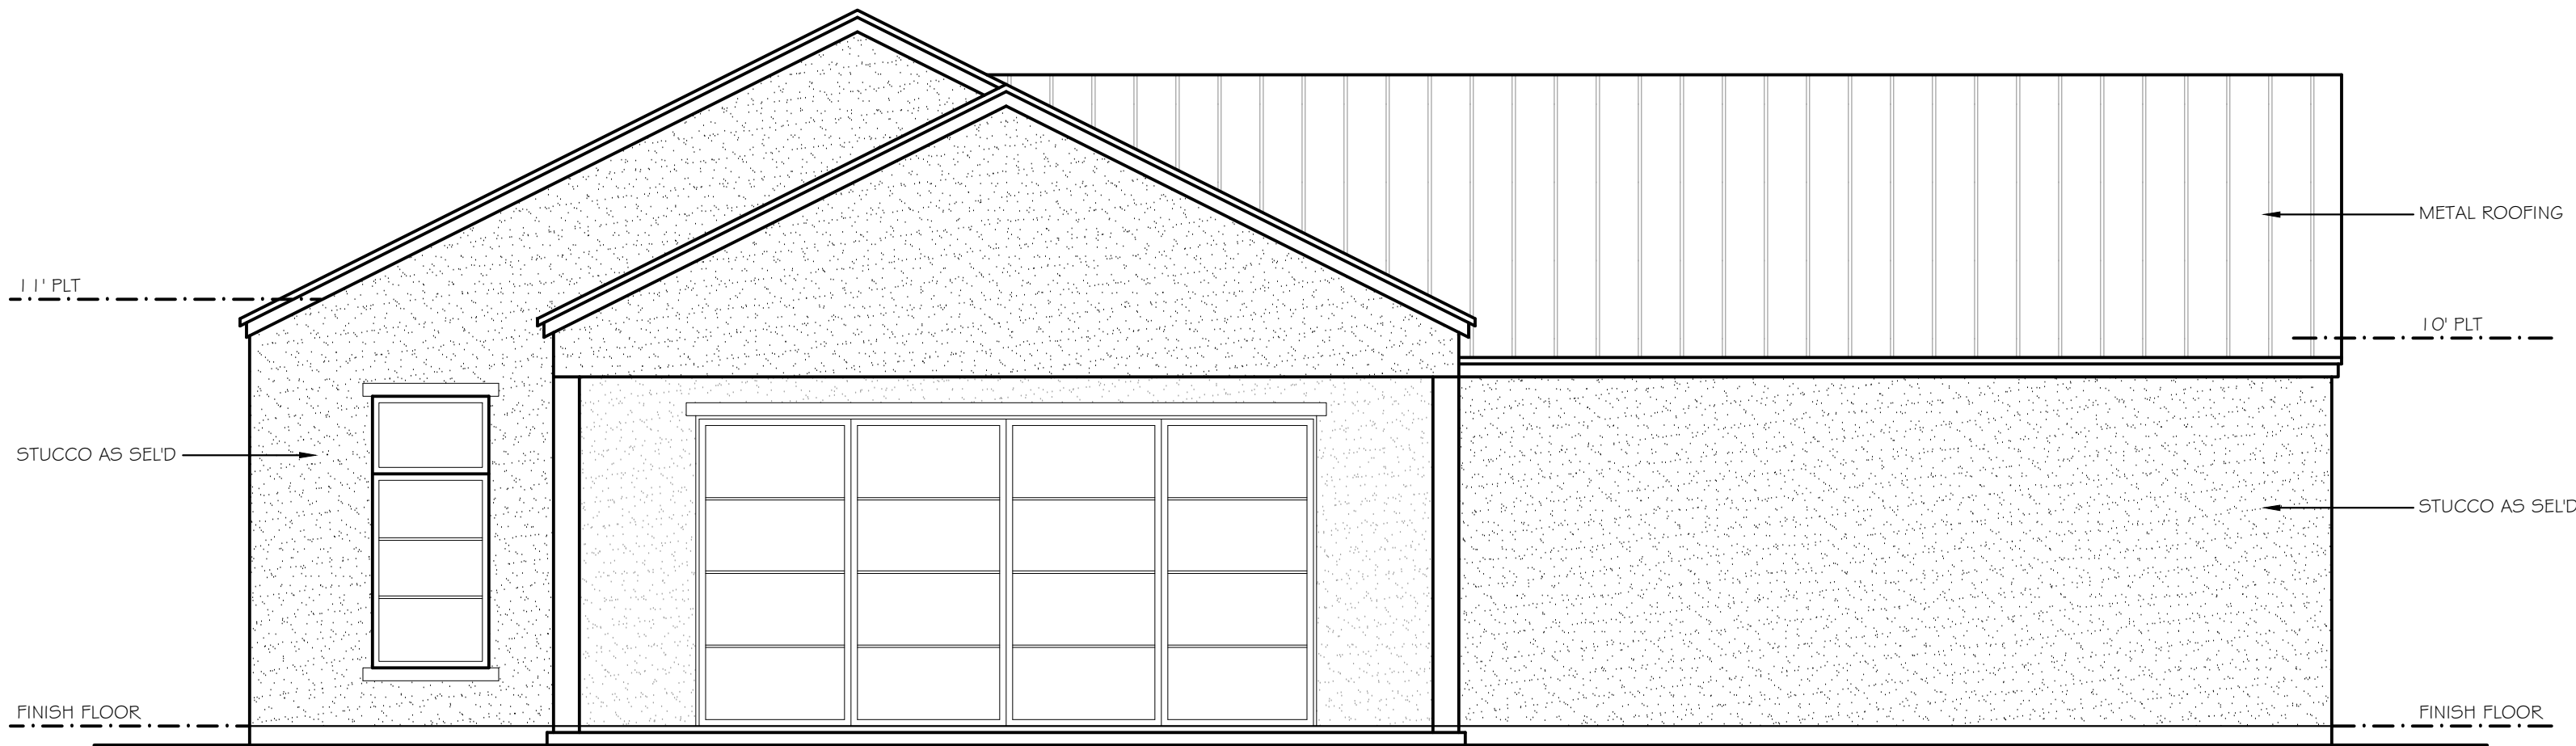

RIGHT ELEVATION

SCALE: 1/4"= 1'-0"

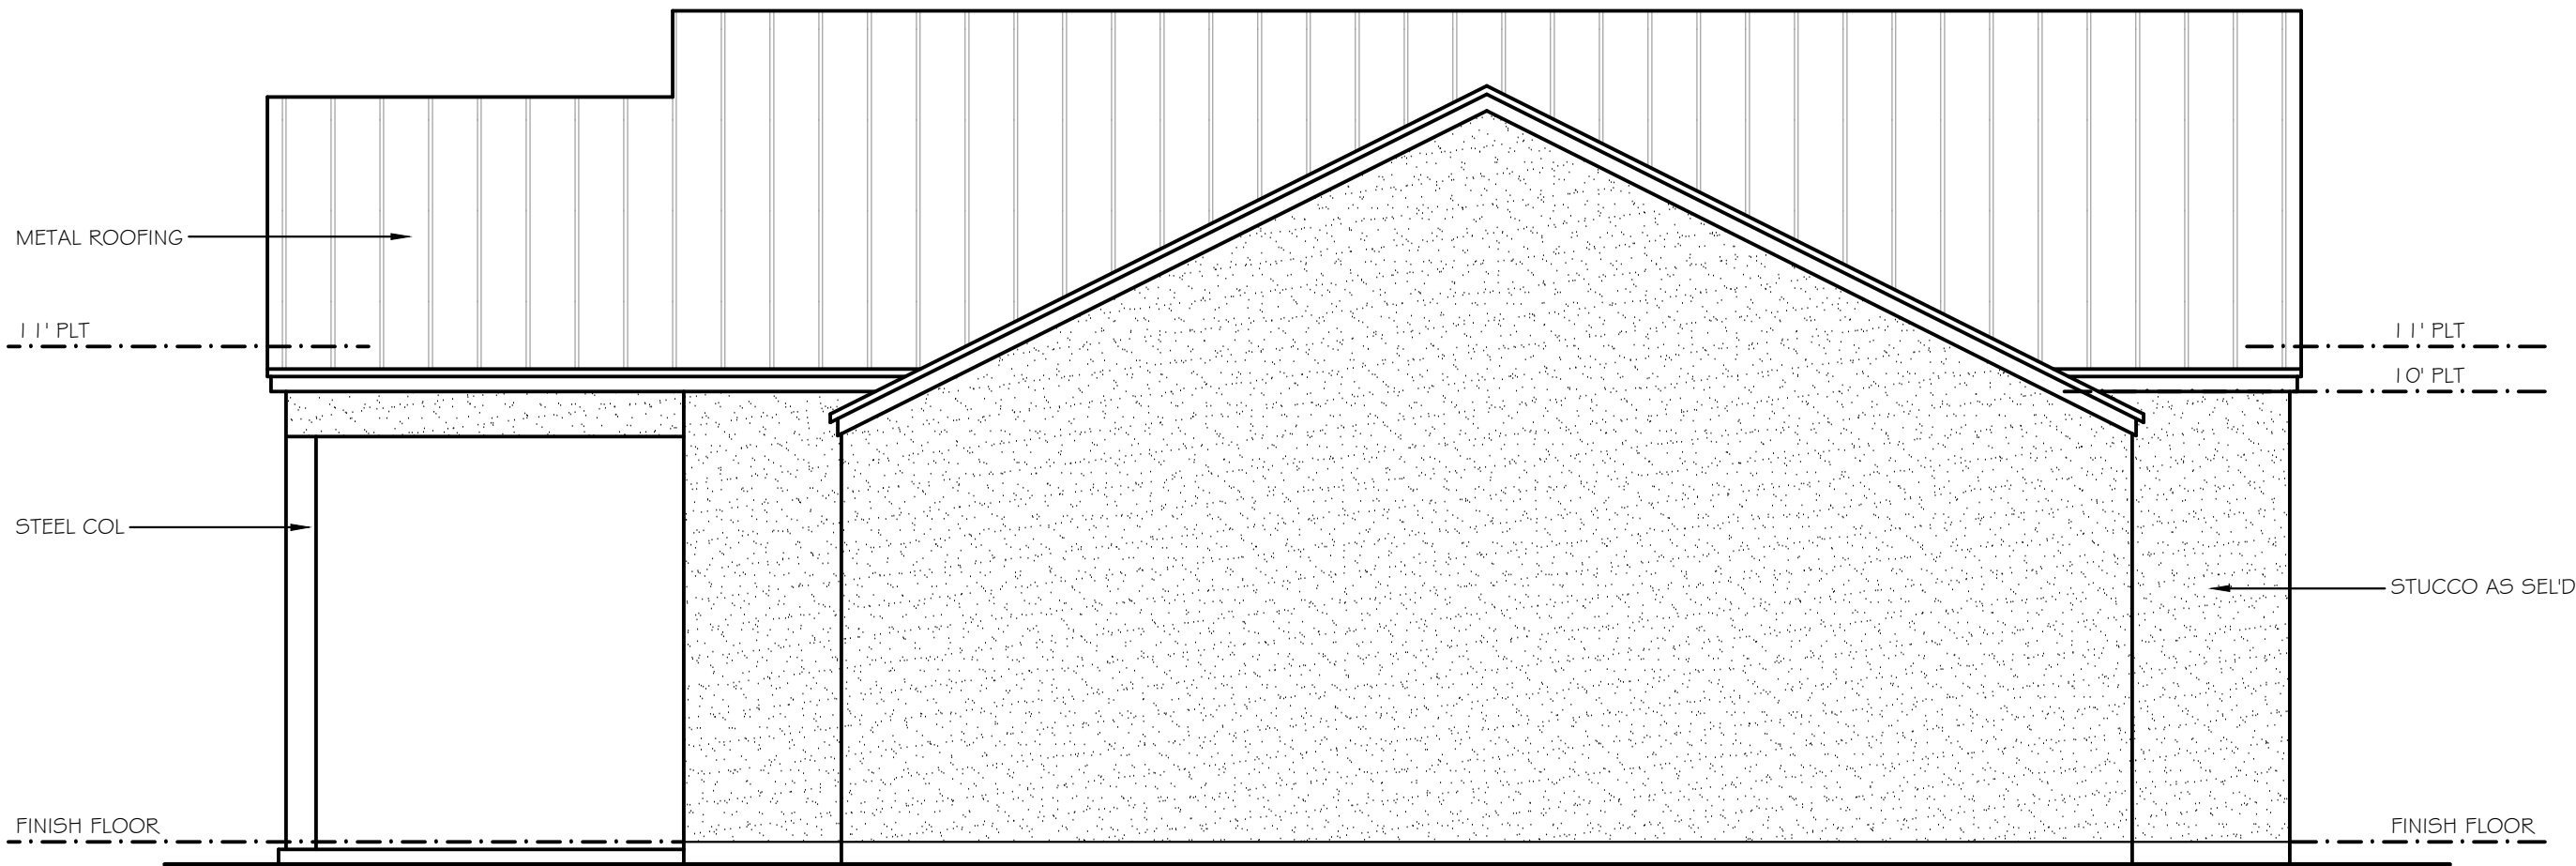

REAR ELEVATION

SCALE: 1/4"= 1'-0"

COPYRIGHT

2022

THESE PLANS WERE DESIGNED/DRAWN BY CHAD NORTON D.B.A. C&C CUSTOM HOME DESIGNS. ALL OWNERSHIP AND COPYRIGHT OF THESE PLANS BELONG EXCLUSIVELY TO CHAD NORTON AND C&C CUSTOM HOME DESIGNS. ANY REPRODUCTION, TRACING, OR RE-SELLING OF THESE PLANS IS PROHIBITED AND SUBJECT TO PROSECUTION BY LAW.

CUSTOM

Drawn By:
CN

Checked By:
CN

THESE PLANS ARE INTENDED TO PROVIDE BASIC CONSTRUCTION INFORMATION, AND ARE FOR ARCHITECTURAL DESIGN ONLY. THESE PLANS MUST BE VERIFIED AND CHECKED BY THE CONTRACTOR/OWNER AND ALL CONTRACTORS OF THIS JOB PRIOR TO CONSTRUCTION. CONTRACTOR/OWNER SHOULD OBTAIN ANY ENGINEERING SERVICES NECESSARY BEFORE BEGINNING CONSTRUCTION OF ANY KIND. ALL FEDERAL, STATE, AND LOCAL CODES AND ORDINANCES TAKE PRECEDENCE OVER ANY PART OF THESE PLANS. DESIGNER WILL NOT ASSUME ANY LIABILITY FOR ANY DAMAGES, DUE TO ERRORS, OMISSIONS, OR CHANGES TO THESE PLANS. THE PURCHASE OF THESE PLANS ENTITLES THE BUYER TO CONSTRUCT THIS HOUSE ONLY ONCE. ANY COPYING, TRACING, OR ALTERING OF THESE PLANS IS NOT PERMITTED. VIOLATORS WILL BE SUBJECT TO PROSECUTION UNDER COPYRIGHT LAWS.

INCLUDED IN THIS SET OF PLANS

SITE PLAN (IF NEEDED)
DIMENSIONED FLOOR PLAN
4 ELEVATIONS
ROOF PLAN
ELECTRICAL PLAN
CLASS C FOUNDATION PLAN

A Custom Residence For:

HUPRICH/KELLEY GUEST HOUSE

Builder:
O

CHAD NORTON
OWNER
(817) 408-5157

C & C

CUSTOM HOME DESIGNS

C & C Custom Home Designs


Plan Name:
H/K GUEST HOUSE

Sheet No:
2 of 3


Date:
8/31/2022 11:46:10 AM

ELECTRICAL LEGEND

-
- BLOCK FOR OPTIONAL
CEILING FAN W/ LITE
KIT
-
- RECESSED INCANDESCENT
-
- RECESSED SPOT
-
- CEILING MOUNTED FIXTURE
-
- PENDANT DROP LIGHT
-
- UNDER CABINET PUCK LIGHT
-
- WALL MOUNTED FIXTURE
-
- UNDER CABINET FLOURESCENT
-
- OVERHEAD PULL CHAIN
-
- EXHAUST FAN WITH LIGHT
-
- EXHAUST FAN
-
- DOUBLE FLOOD LIGHTS
-
- SWITCH
-
- SWITCH WITH DIMMER
-
- 110-VOLT OUTLET
-
- 220-VOLT OUTLET
-
- WEATHERPROOFED, GROUNDED 110-VOLT
-
- GROUNDED 110-VOLT OUTLET
-
- 1/2 HOT 110-VOLT OUTLET
-
- CEILING 110-VOLT OUTLET
-
- FLOOR 110-VOLT OUTLET
-
- PHONE
-
- TV ANTENNA
-
- SMOKE DETECTOR
-
- INTERCOM
-
- MASTER INTERCOM
-
- ELECTRIC EYE
-
- SECURITY KEY PAD
-
- DOORBELL
-
- CHIME
-
- GAS HOOK-UP
-
- HOSE BIBB

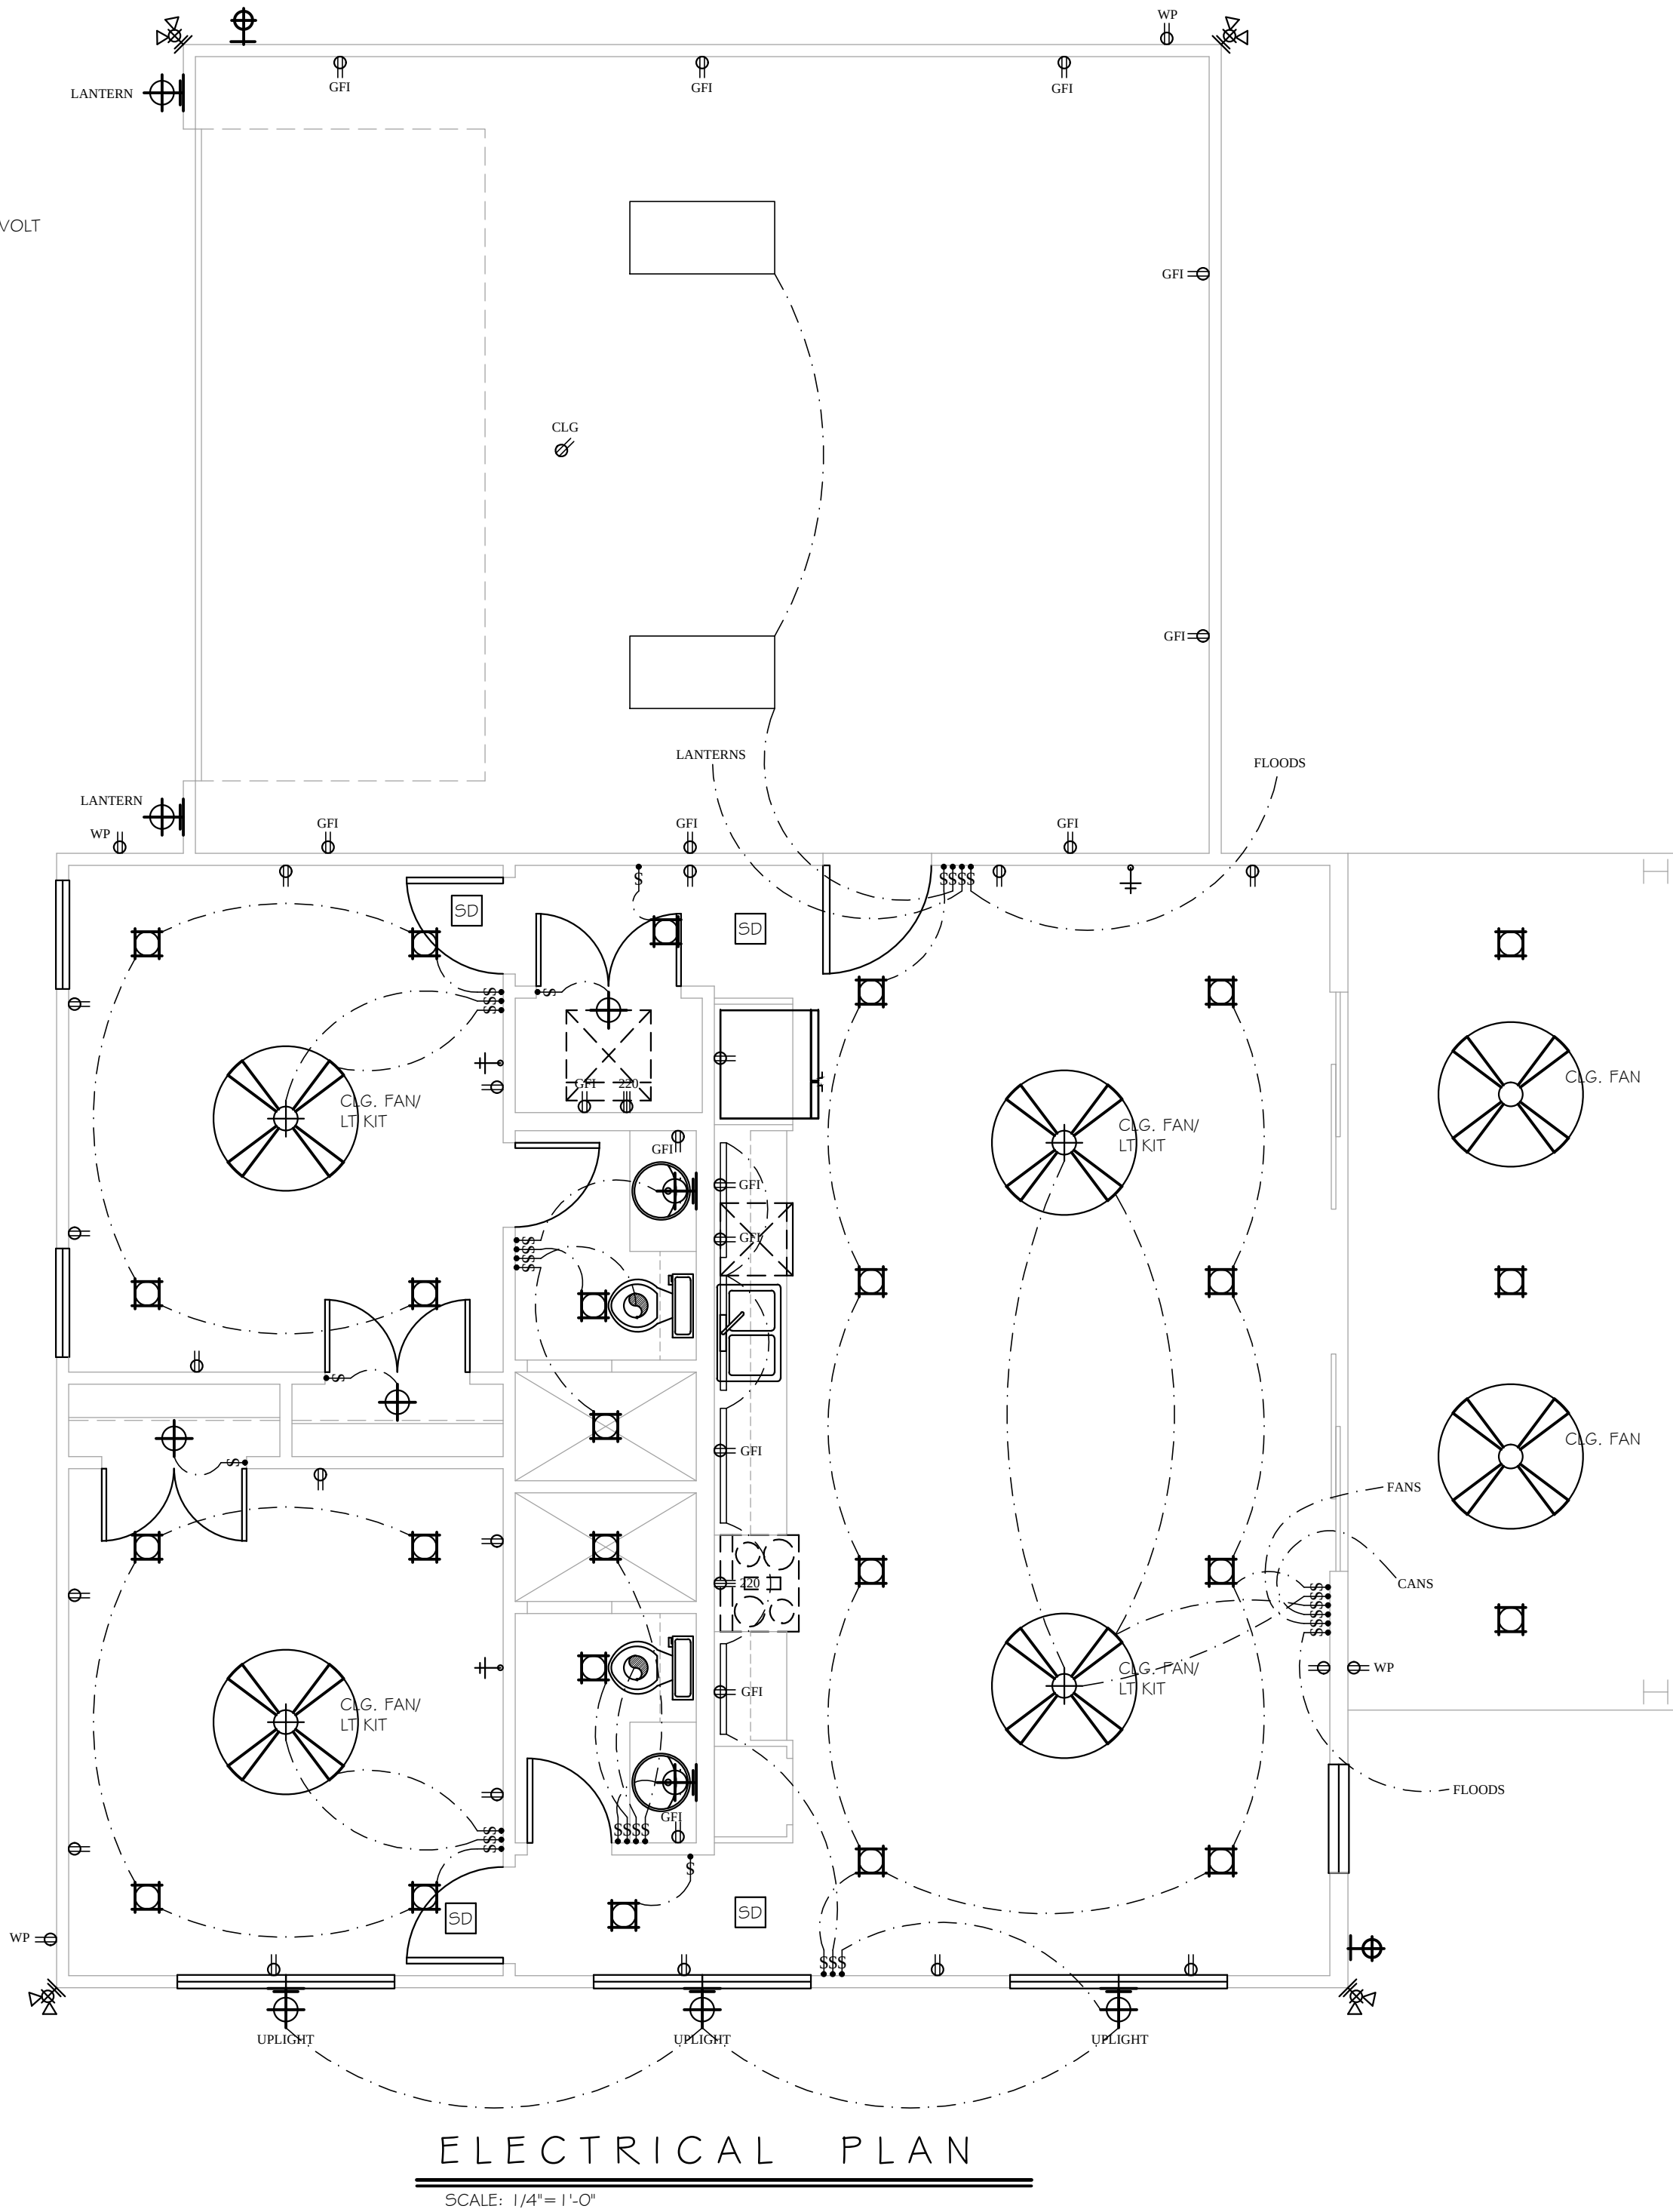

ELECTRICAL PLAN
SCALE: 1/4"=1'-0"

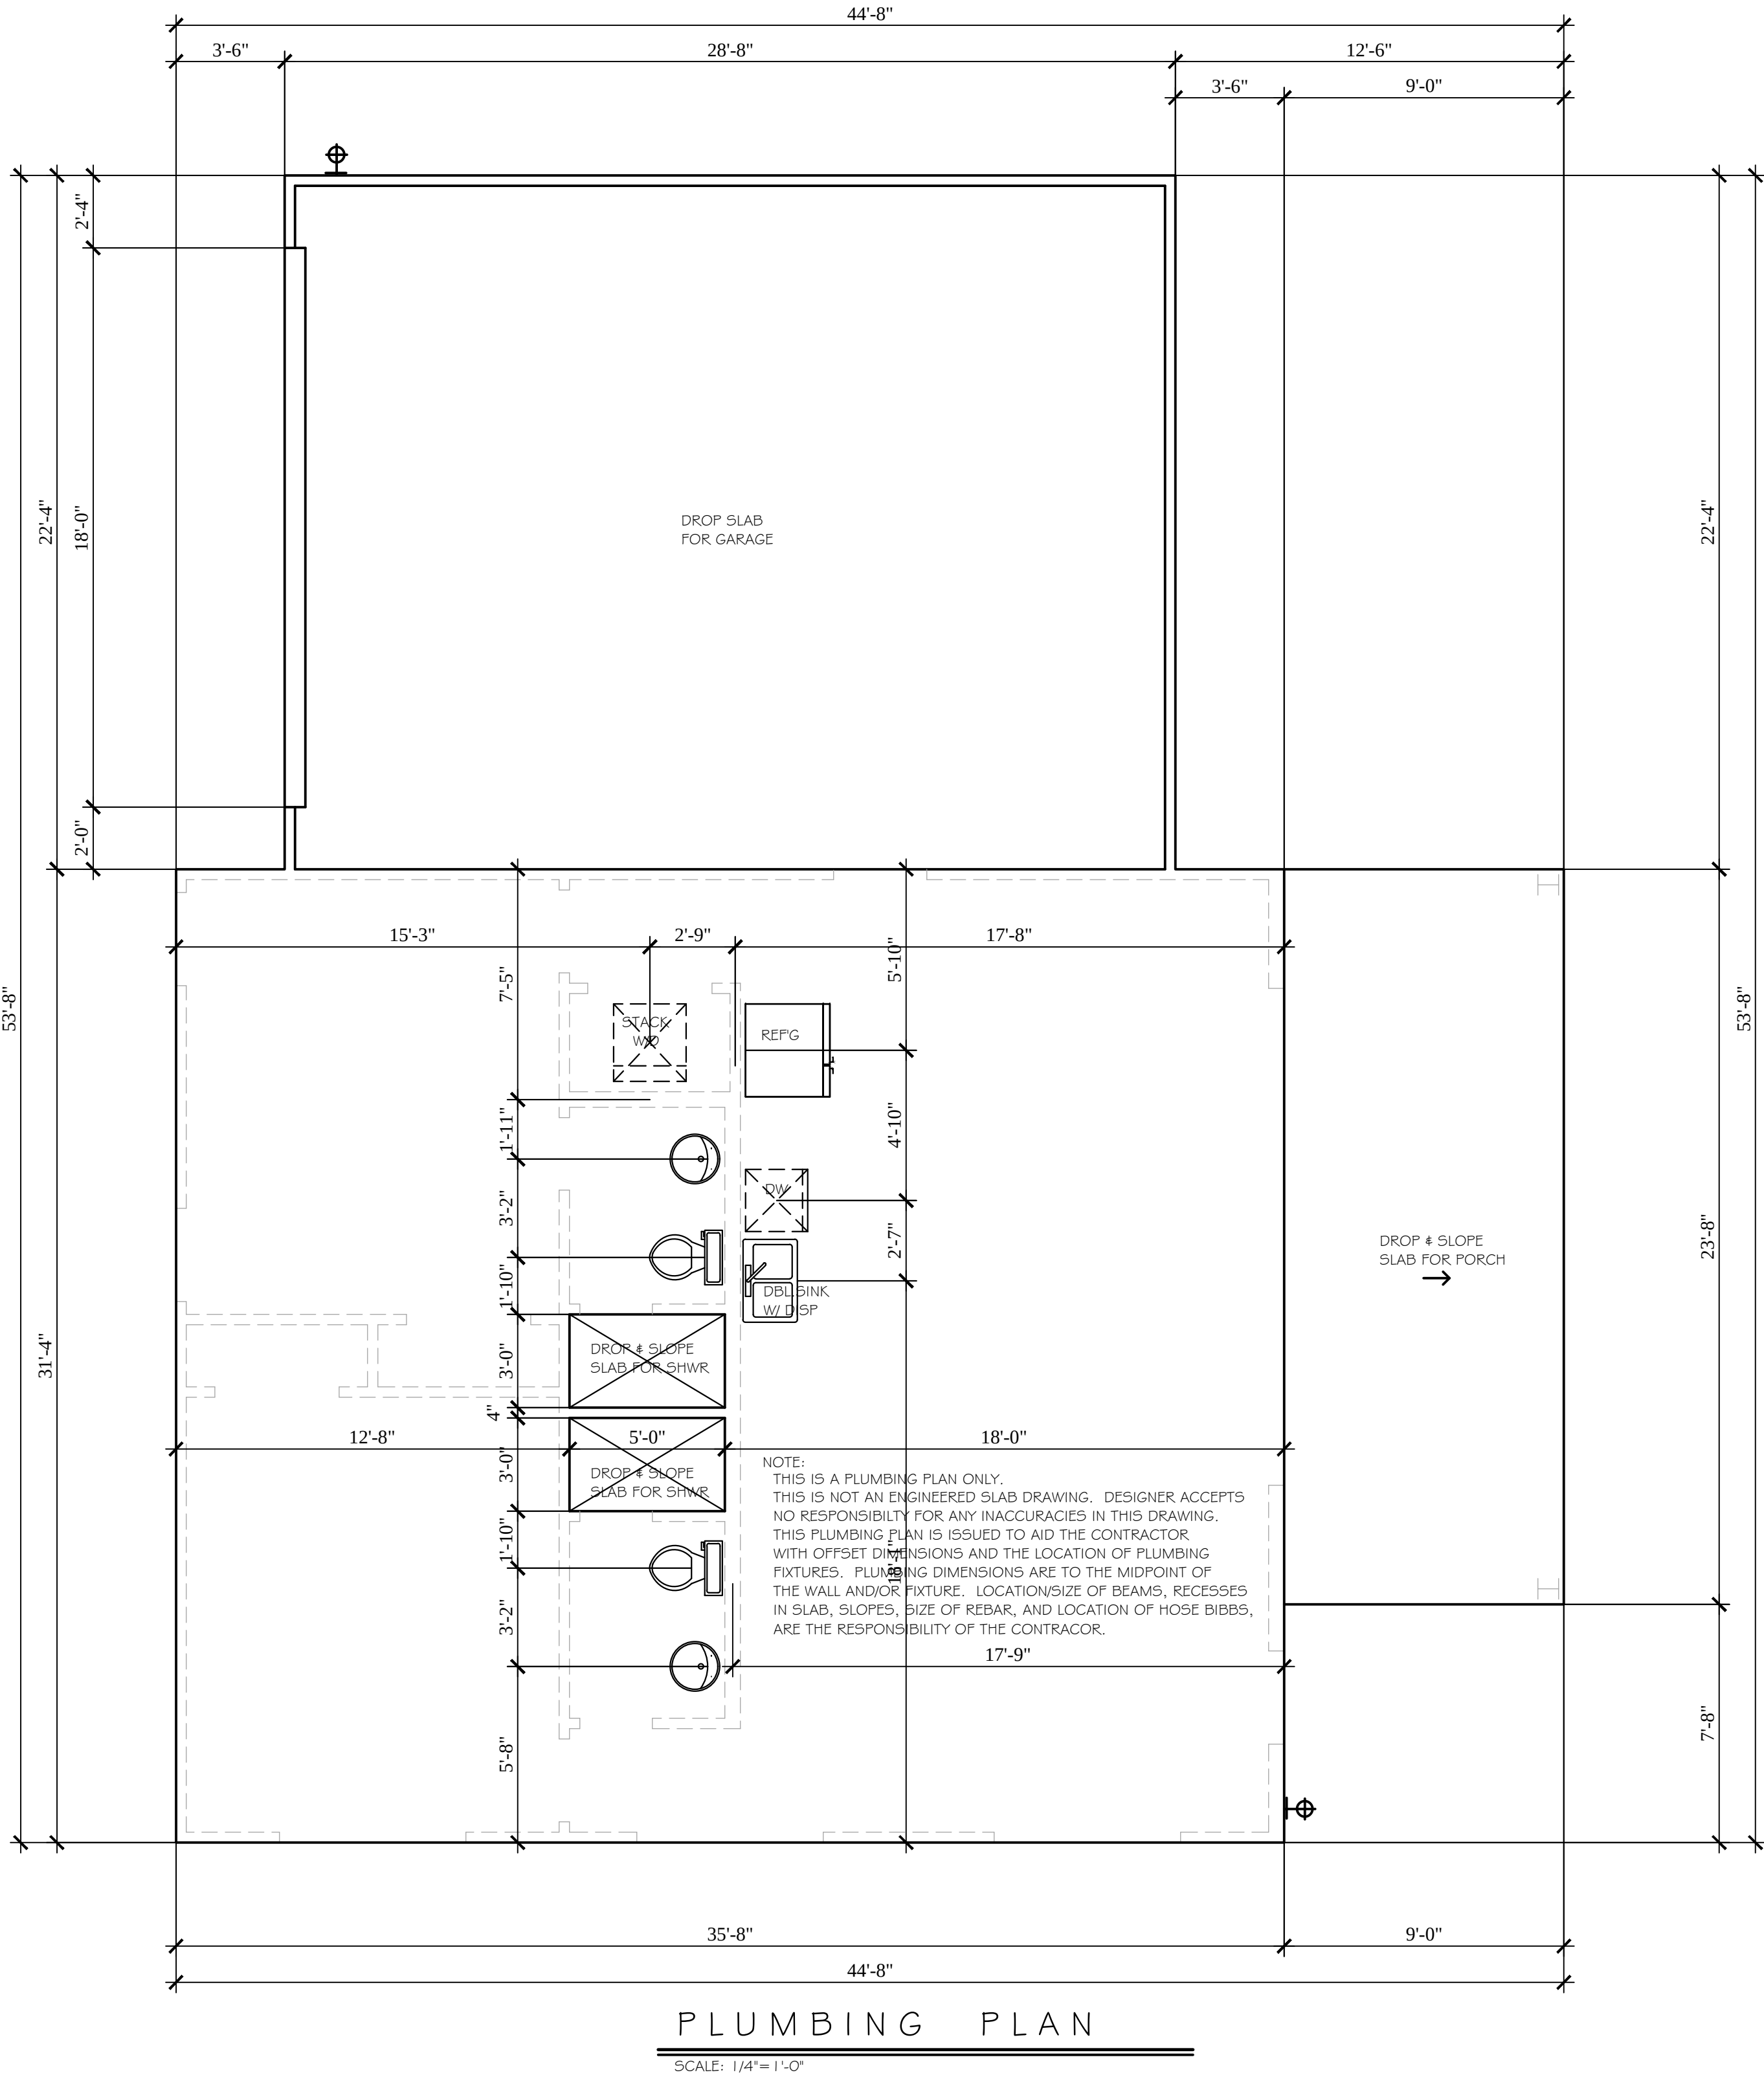

PLUMBING PLAN
SCALE: 1/4"=1'-0"

COPYRIGHT

2022

THESE PLANS WERE DESIGNED/DRAWN BY CHAD NORTON D.B.A. C&C CUSTOM HOME DESIGNS. ALL OWNERSHIP AND COPYRIGHT OF THESE PLANS BELONG EXCLUSIVELY TO CHAD NORTON AND C&C CUSTOM HOME DESIGNS. ANY REPRODUCTION, TRACING, OR RE-SELLING OF THESE PLANS IS PROHIBITED AND SUBJECT TO PROSECUTION BY LAW.

Plan Name:

H/K GUEST HOUSE

Sheet No:

3 of 3

Date:

8/31/2022 11:46:25 AM

CHAD NORTON

OWNER

(817) 408-5157

CUSTOM HOME DESIGNS

C & C Custom Home Designs

INCLUDED IN THIS SET OF PLANS

SITE PLAN (IF NEEDED)

DIMENSIONED FLOOR PLAN

4 ELEVATIONS

ROOF PLAN

ELECTRICAL PLAN

CLASS C FOUNDATION PLAN

A Custom Residence For:

HUPRICH/KELLEY GUEST HOUSE

Builder:

O

CUSTOM

Drawn By:

CN

Checked By:

CN

THESE PLANS ARE INTENDED TO PROVIDE BASIC CONSTRUCTION INFORMATION, AND ARE FOR ARCHITECTURAL DESIGN ONLY. THESE PLANS MUST BE VERIFIED AND CHECKED BY THE CONTRACTOR/OWNER AND ALL CONTRACTORS OF THIS JOB PRIOR TO CONSTRUCTION. CONTRACTOR/OWNER SHOULD OBTAIN ANY ENGINEERING SERVICES NECESSARY BEFORE BEGINNING CONSTRUCTION OF ANY KIND. ALL FEDERAL, STATE, AND LOCAL CODES AND ORDINANCES TAKE PRECEDENCE OVER ANY PART OF THESE PLANS. DESIGNER WILL NOT ASSUME ANY LIABILITY FOR ANY DAMAGES, DUE TO ERRORS, OMISSIONS, OR CHANGES TO THESE PLANS. THE PURCHASE OF THESE PLANS ENTITLES THE BUYER TO CONSTRUCT THIS HOUSE ONLY ONCE. ANY COPYING, TRACING, OR ALTERING OF THESE PLANS IS NOT PERMITTED. VIOLATORS WILL BE SUBJECT TO PROSECUTION UNDER COPYRIGHT LAWS.